


CITY OF COLLEGE PLACE MUNICIPAL BUILDING

COLLEGE PLACE,
WASHINGTON

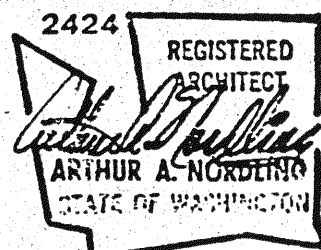

Architects & Engineers

INTÉGRUS ARCHITECTURE

244 West Main Avenue
Spokane, Washington 99201
509/838-8681
FAX 509/838-2194


Mechanical/Electrical Engineers

MW Consulting Engineers
Great Northwest Bldg., Suite 200
222 North Wall Street
Spokane, Washington 99201-0877
509/838-9020
FAX 509/838-1123

Job Number 9119.50
Drawn By WJ SL
Checked By
Date 9-10-91
Revisions

Sheet Contents
WALL SECTIONS

A5

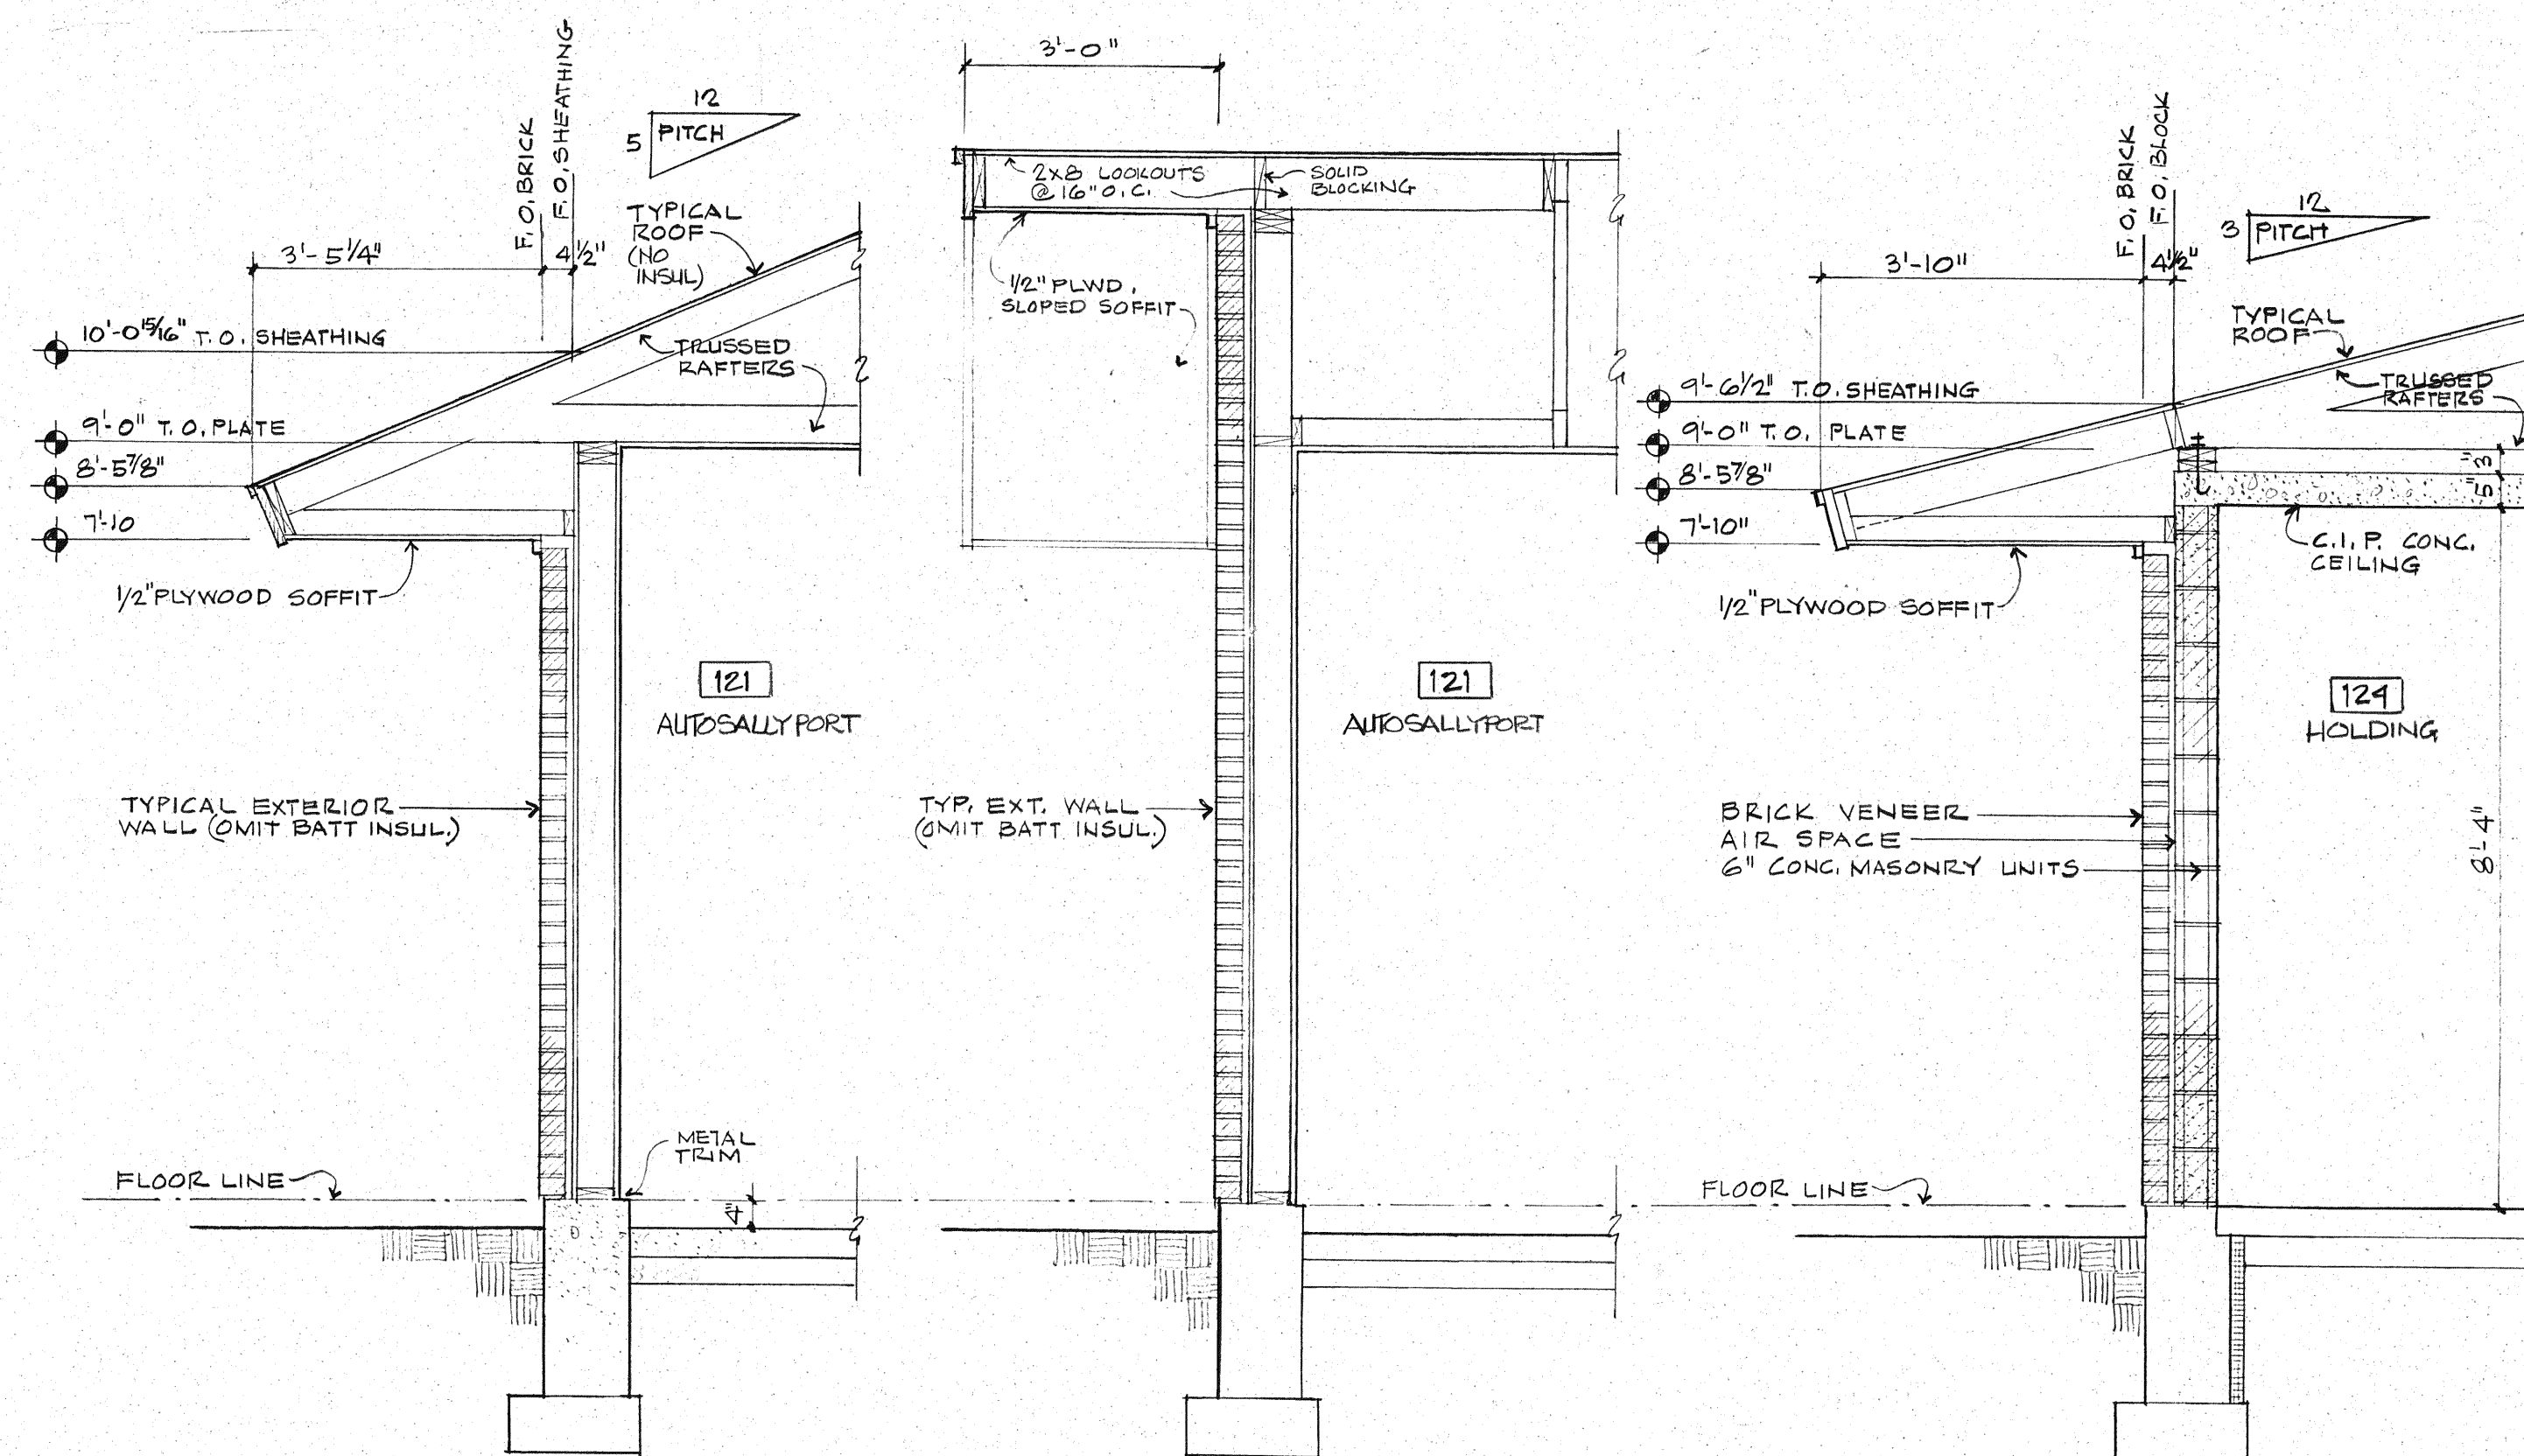

F WALL SECTION
SCALE - 1/2" = 1'-0"


G WALL SECTION
1/2" = 1'-0"

H WALL SECTION
1/2" = 1'-0"

J WALL SECTION
SCALE - 1/2" = 1'-0"

K WALL SECTION
1/2" = 1'-0"

L WALL SECTION
1/2" = 1'-0"

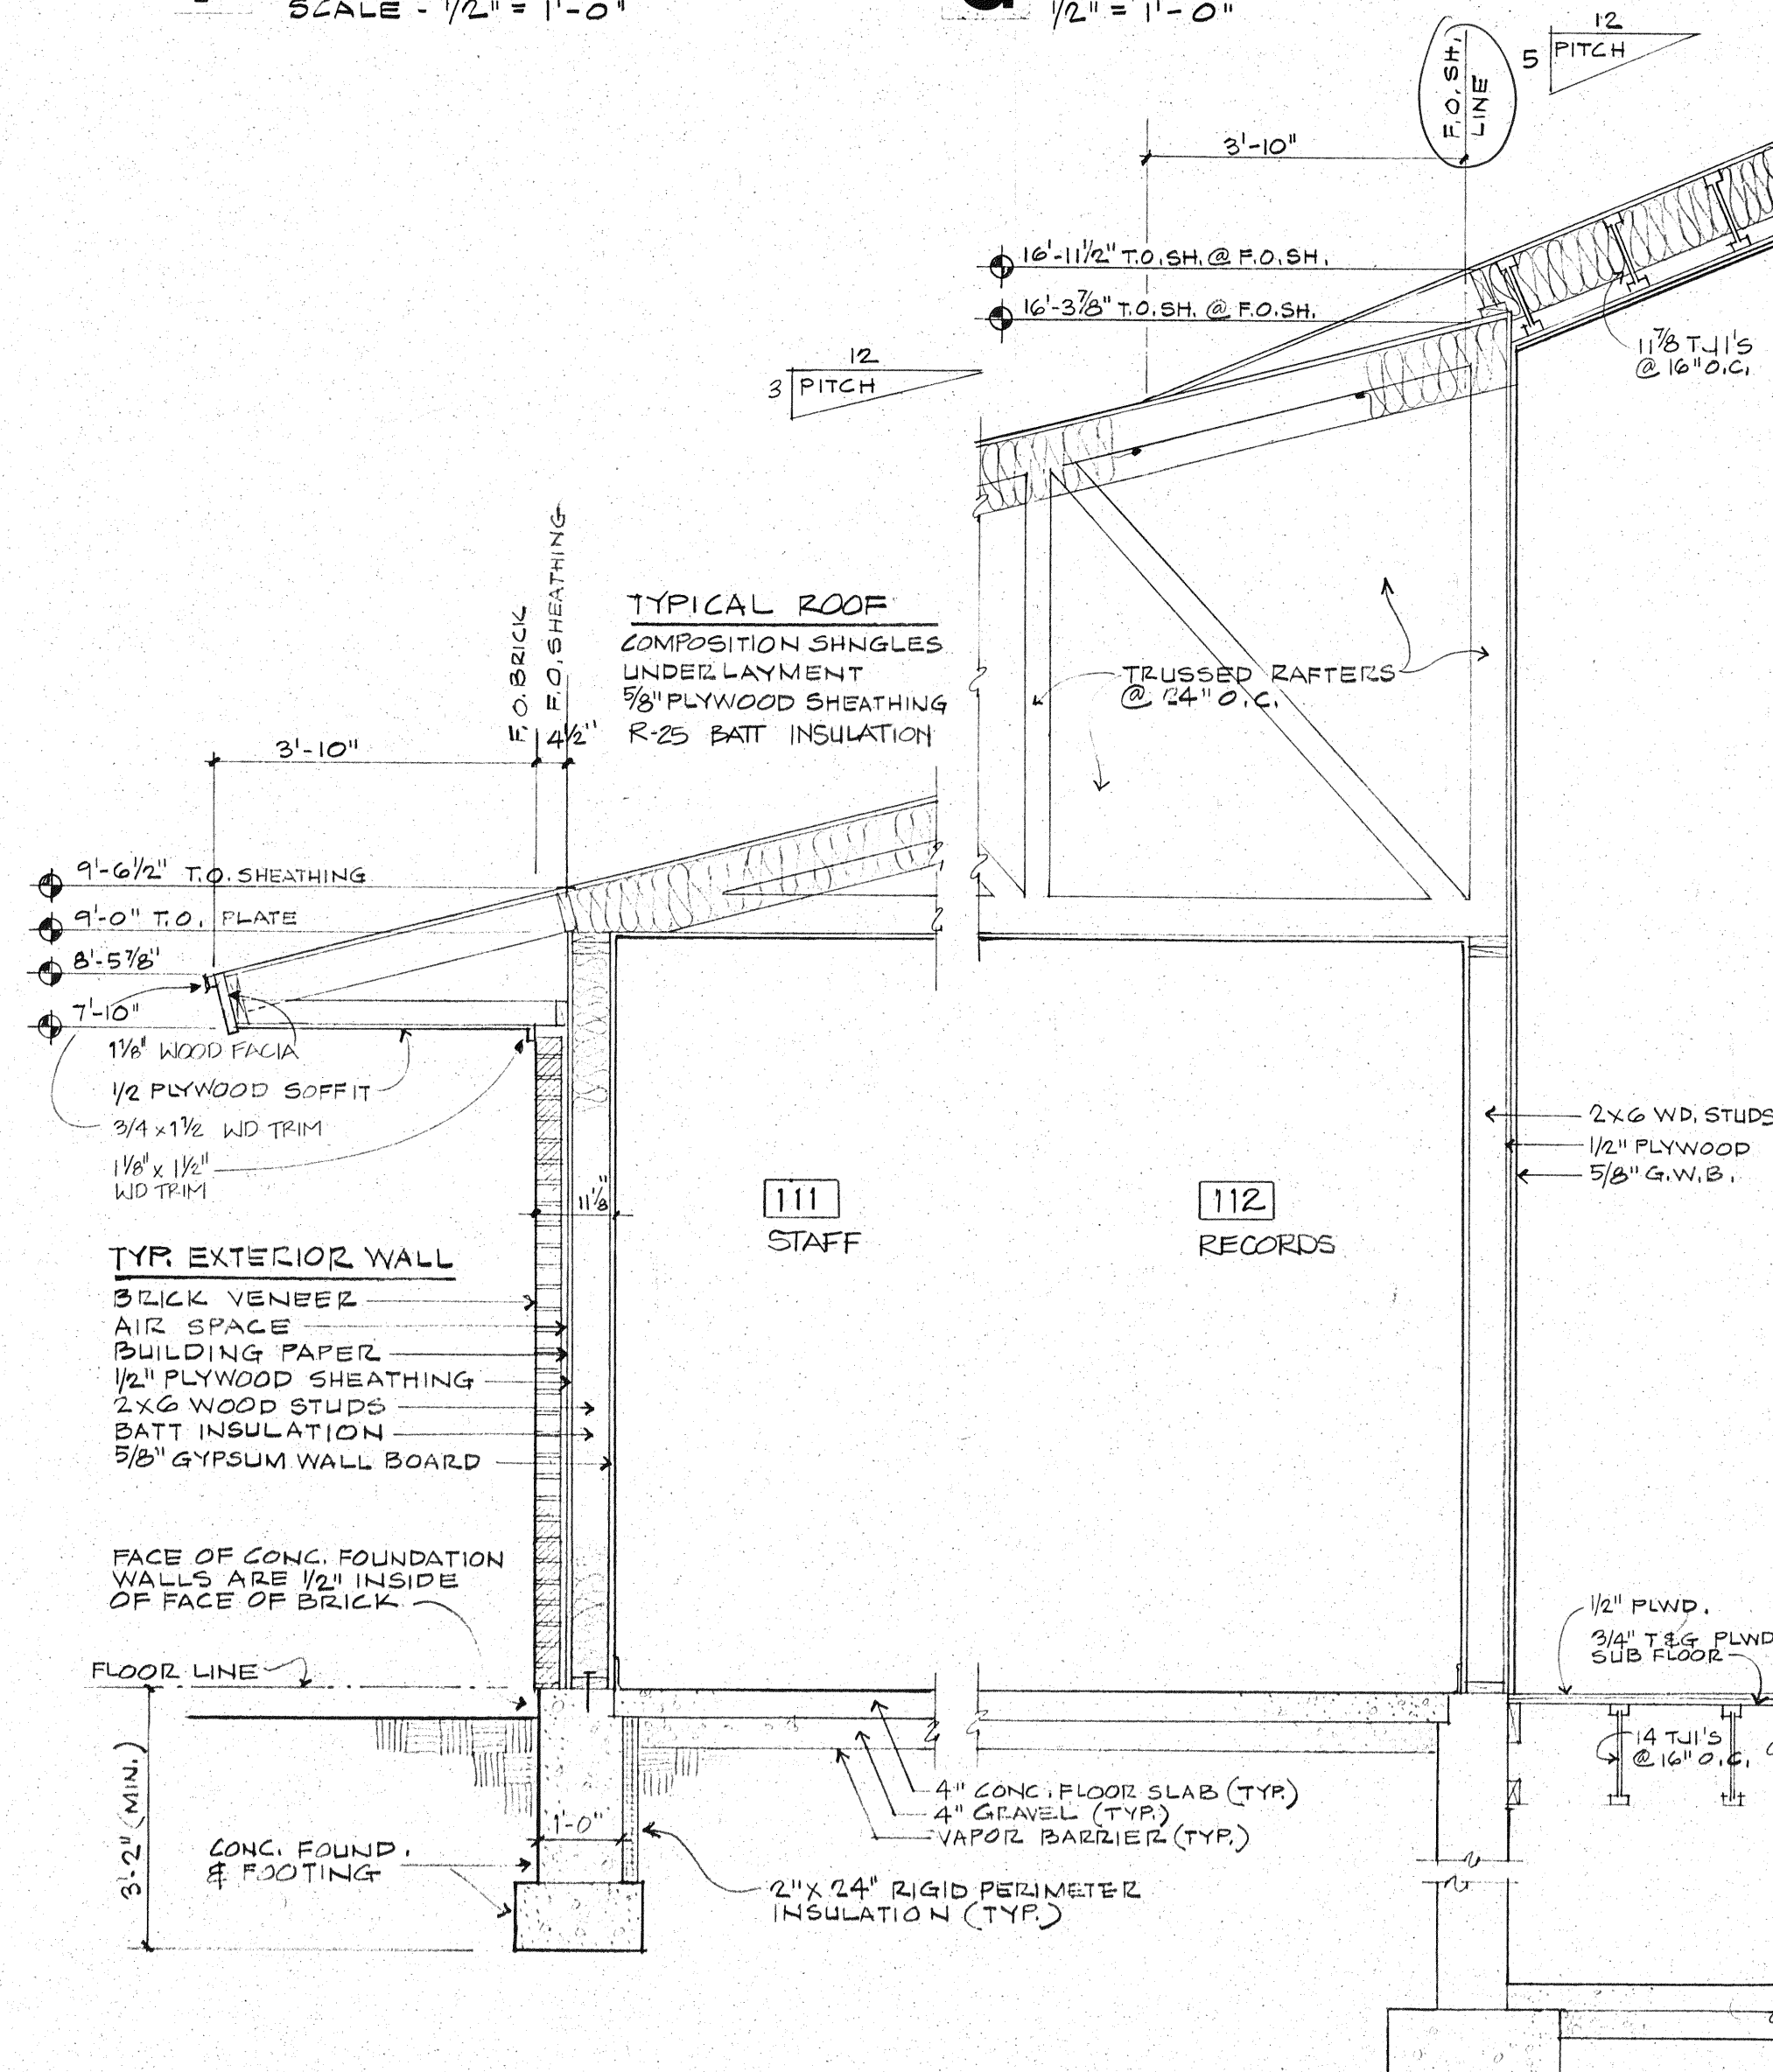


A WALL SECTION
SCALE - 1/2" = 1'-0"

B WALL SECTION
1/2" = 1'-0"

C WALL SECTION
1/2" = 1'-0"

D WALL SECTION
1/2" = 1'-0"

E WALL SECTION
SCALE - 1/2" = 1'-0"

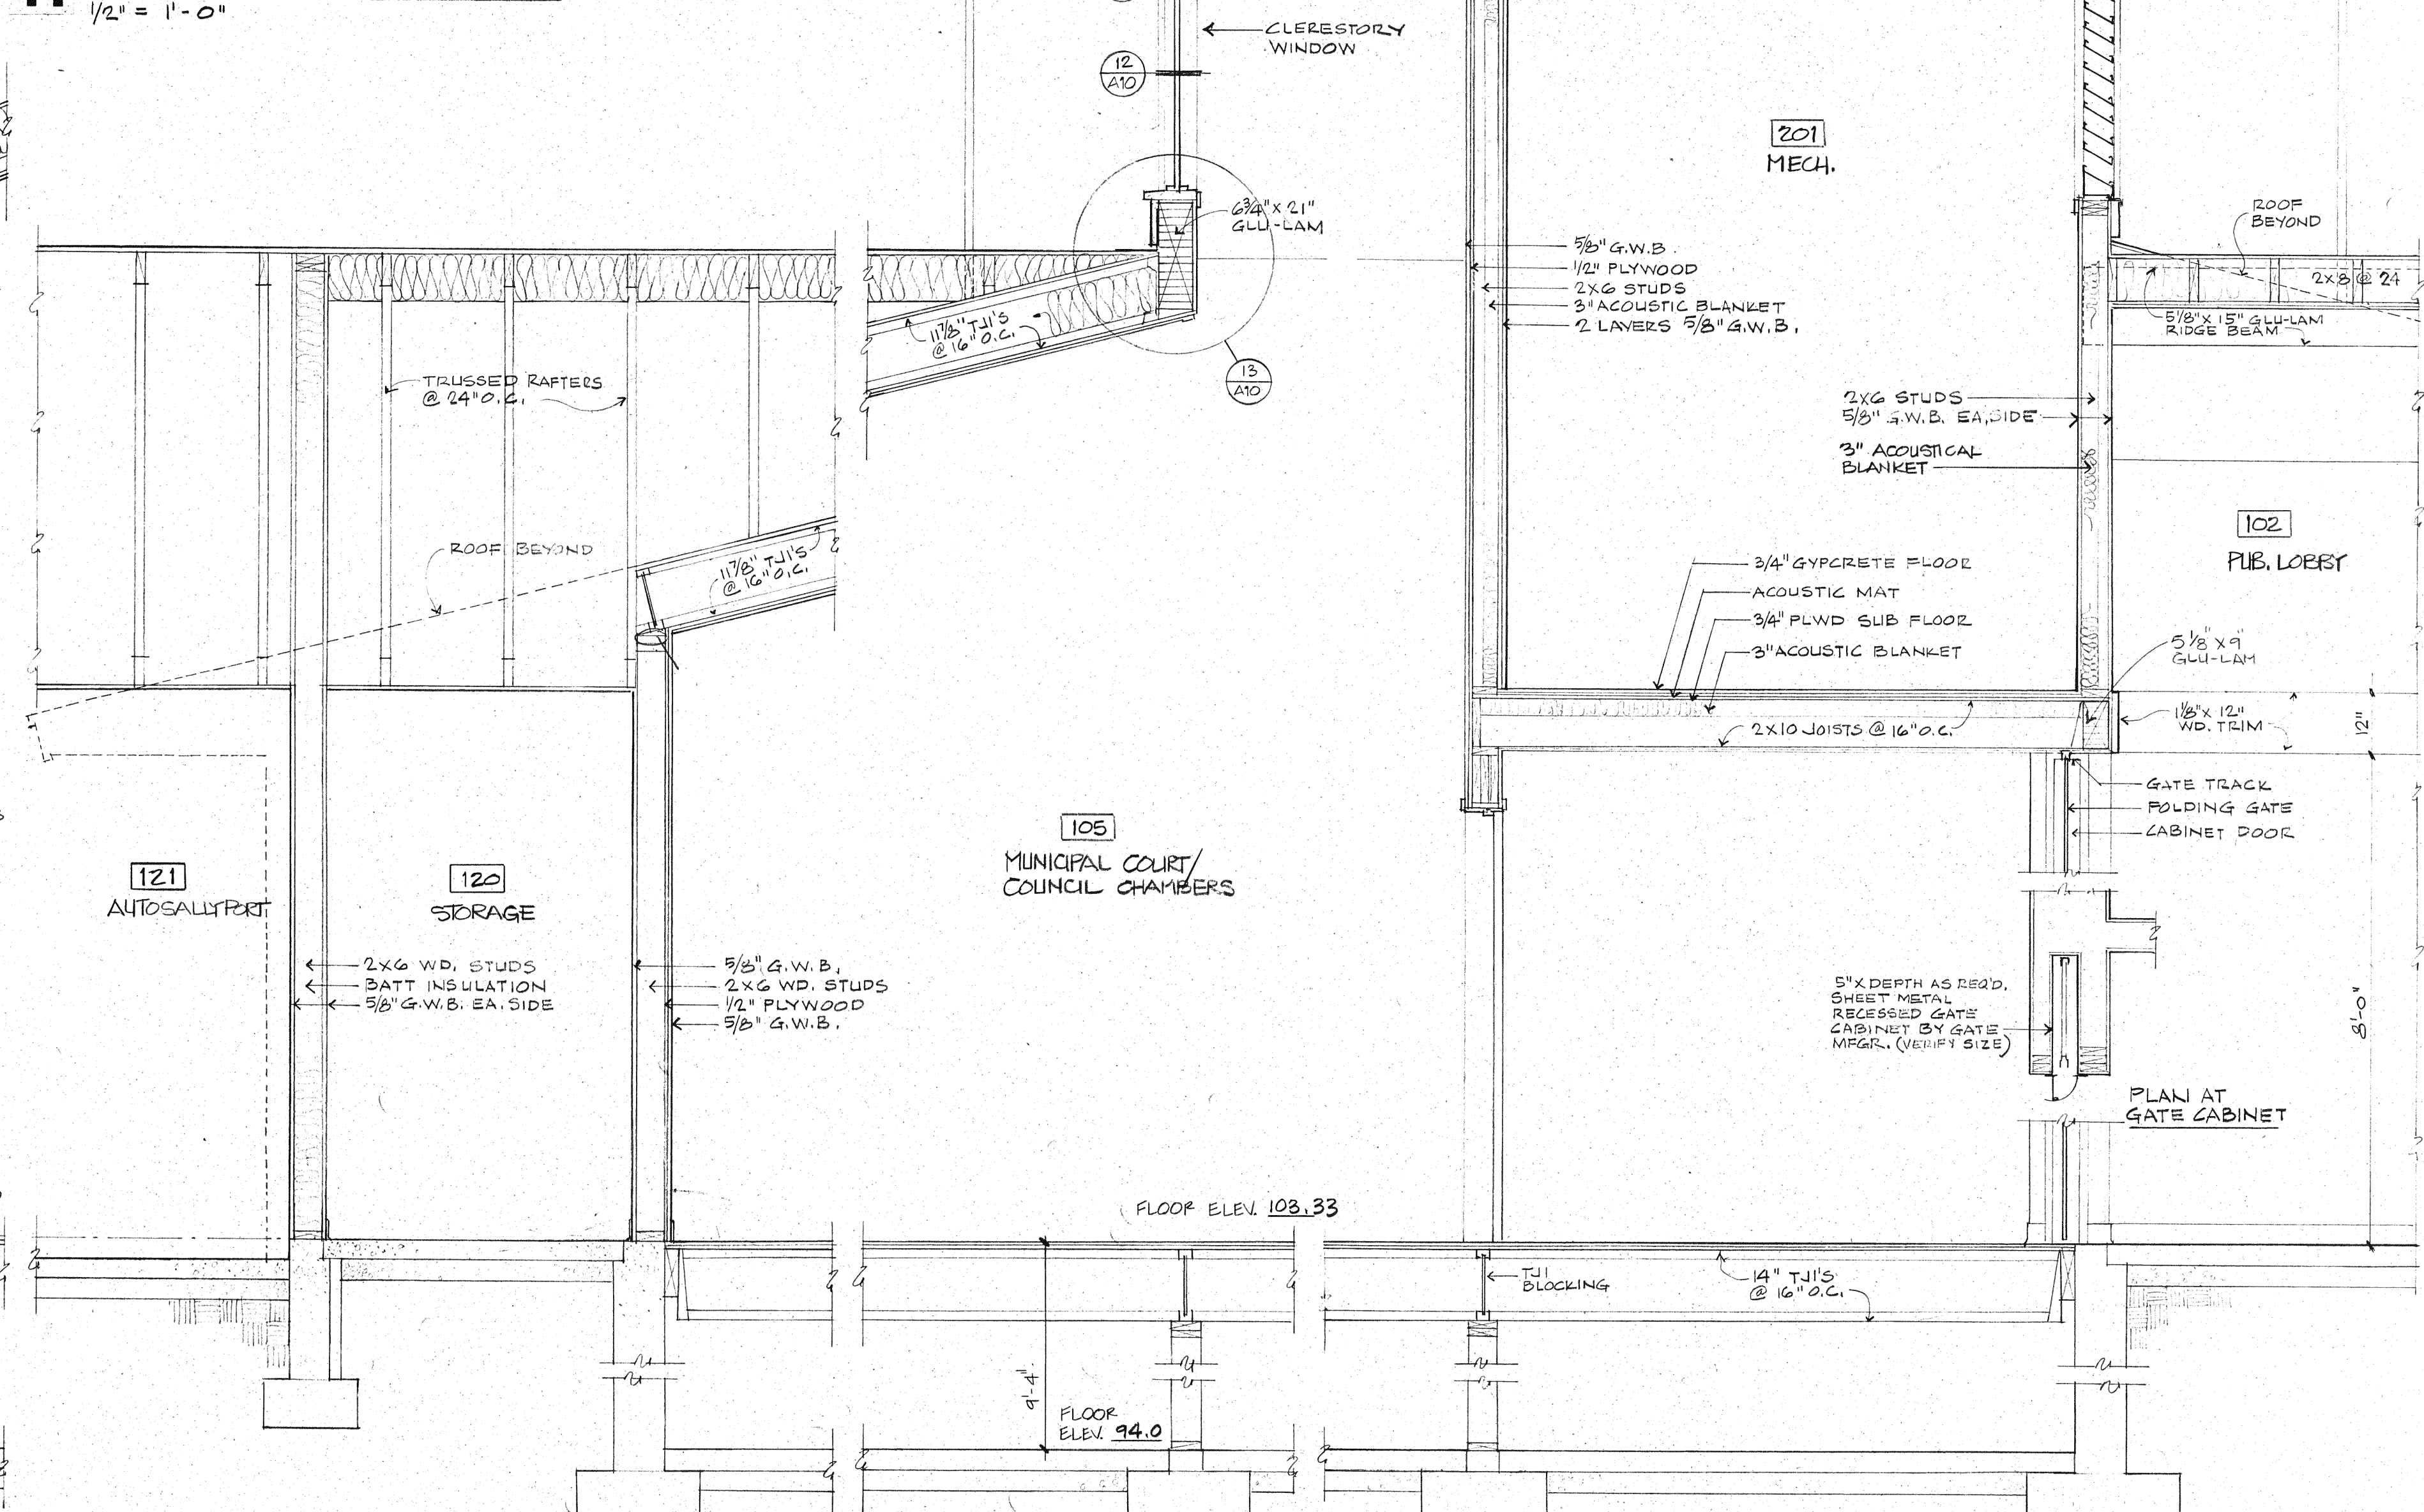

Job Number 9119.50
Drawn By WJ SL
Checked By
Date 9-10-91
Revisions

Sheet Contents
WALL SECTIONS

A5