



BASEMENT LIGHTING PLAN -
ALTERNATE #2

SCALE: 1/8" = 1'-0"

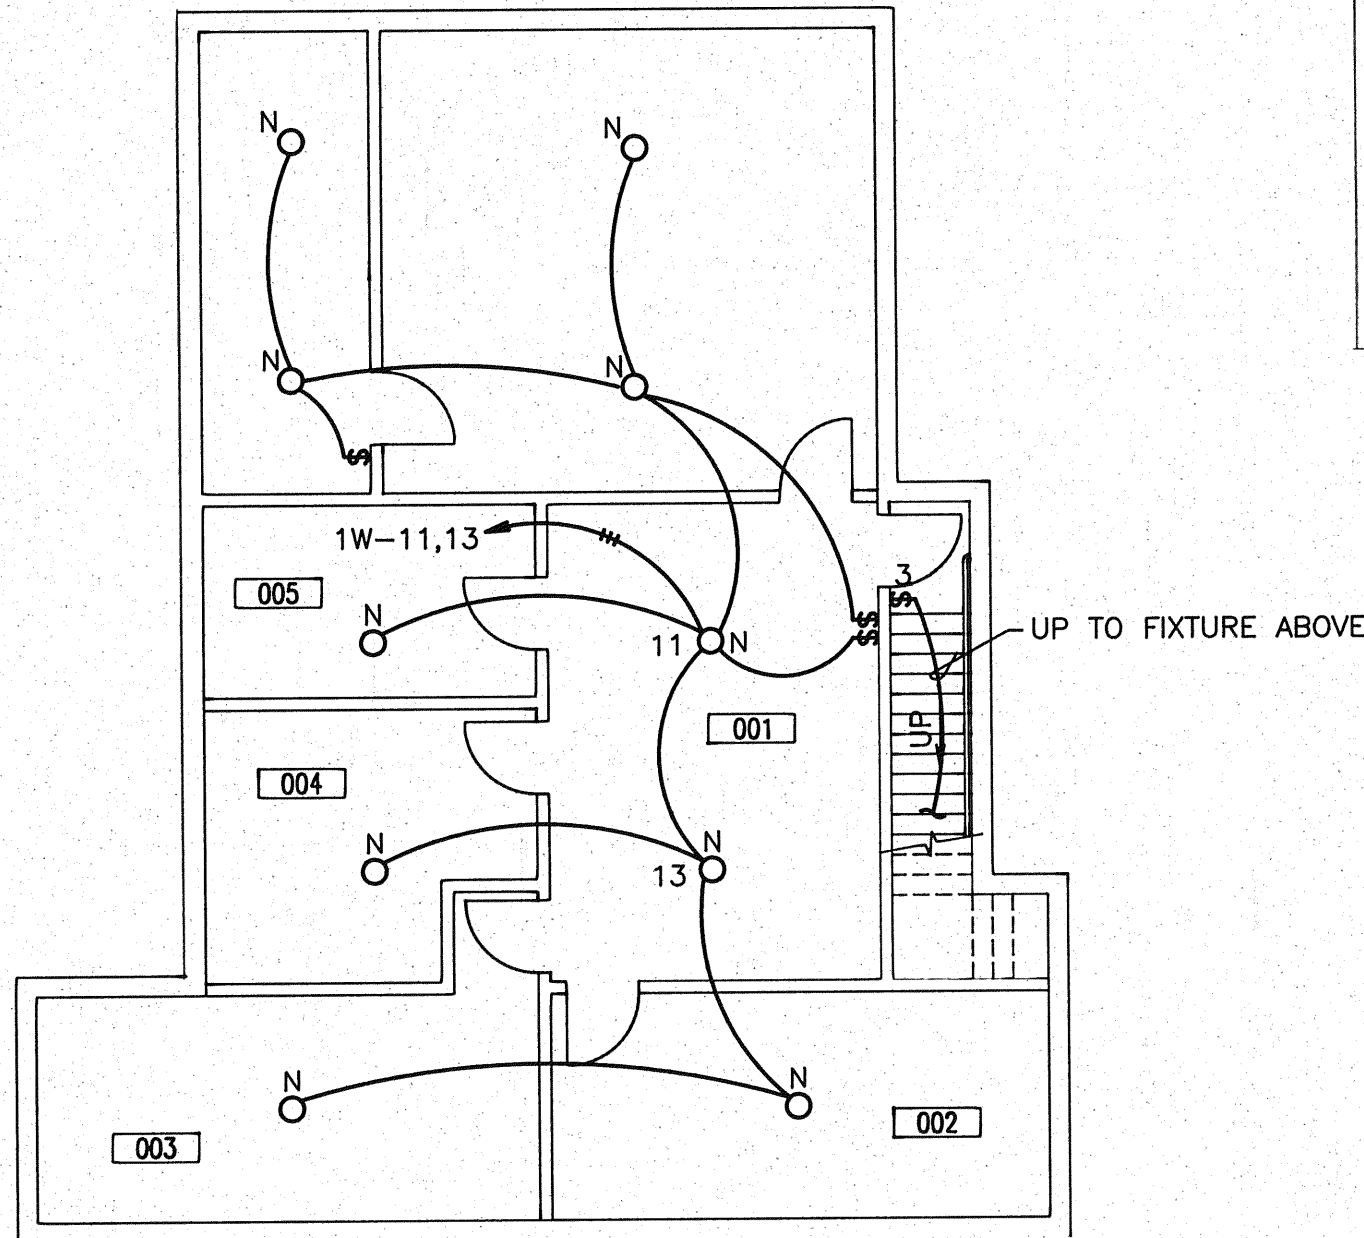


BASEMENT FLOOR PLAN - LIGHTING

SCALE: 1/8" = 1'-0"

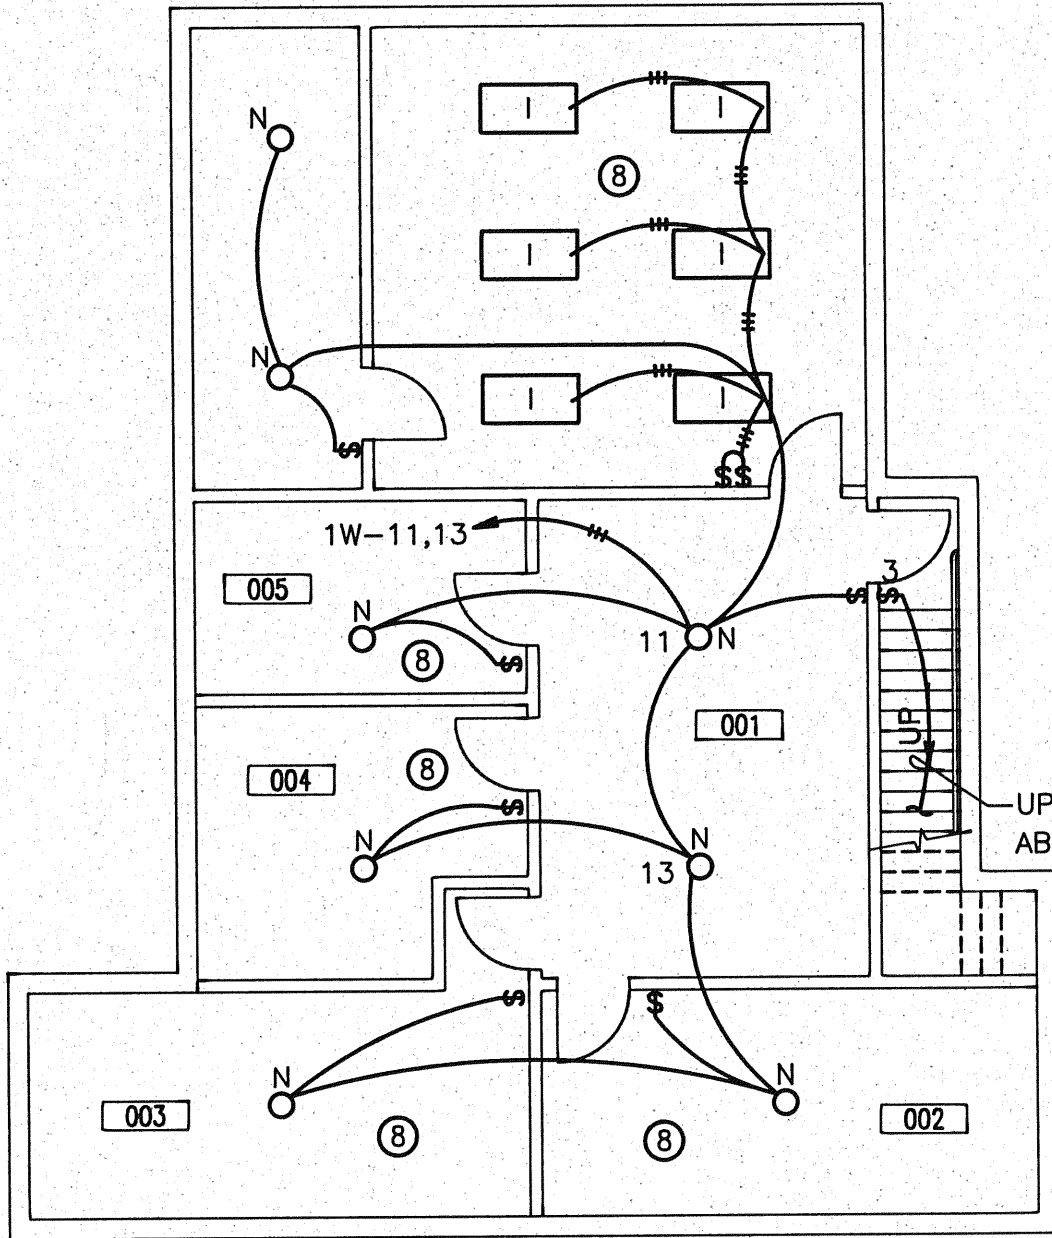

KEY NOTES:

- 1 PENDANTS FOR PENDANT MOUNT FIXTURES SHALL BE OF THE LENGTH REQUIRED TO ACHIEVE A 10' DISTANCE FROM BOTTOM OF FIXTURE TO FINISHED FLOOR. APPLICABLE TO TYPE 'B', TYPE 'P' AND TYPE 'T' FIXTURES.
- 2 PULL-DOWN STAIR WILL BE UTILIZED THIS ROOM FOR ACCESS TO MECHANICAL ROOM ABOVE. VERIFY EXACT LOCATION OF STAIR ACCESS WITH ARCHITECTURAL DRAWINGS, AND COORDINATE POSITIONING OF LIGHT FIXTURES THIS ROOM.
- 3 ALL LIGHTING FIXTURES NOTED "NL" (NIGHT LIGHT) SHALL BE CONNECTED TO EMERGENCY GENERATOR CIRCUITS.
- 4 LIGHT FIXTURE TYPE "R" TO BE SURFACE MOUNTED TO THE BOTTOM OF SOFFIT IN LOCATION SHOWN. PROVIDE WEATHERPROOF JUNCTION BOX WITH GASKETED COVER, AND ALL MOUNTING HARDWARE AS REQUIRED.
- 5 PHOTOCELL SHALL BE MOUNTED ON ROOF IN UNOBTUSIVE PLACE PER THE SPECIFICATION. PROVIDE CONDUIT ROOF PENETRATION, FLASHING, ETC. PER THE SPECIFICATIONS. MOUNT PHOTOCELL IN LOCATION WHERE OPERATION IS NOT AFFECTED BY ARTIFICIAL LIGHT TO PREVENT CYCLING. PHOTOCELL TO BE ORIENTED NORTH.
- 6 COORDINATE MOUNTING OF FIXTURES WITH OVERHEAD DOOR HARDWARE. IF RELOCATION OF FIXTURES DUE TO OVERHEAD DOOR IS REQUIRED, SUBMIT ON PROPOSED ARRANGEMENT AND/OR ALTERNATE MOUNTING MEANS.
- 7 CONTRACTOR TO COORDINATE EXACT POSITIONING OF LIGHT FIXTURES WITH FURNITURE LAYOUT THIS ROOM. VERIFY THIS REQUIREMENT WITH OWNER.
- 8 UNDER ALTERNATE #2, PROVIDE LIGHTING AND SWITCHING MODIFICATIONS AS INDICATED ON FLOOR PLAN. SURFACE MOUNTED FLUORESCENT LIGHTING WITH 2-LEVEL SWITCHING WILL BE UTILIZED IN FUTURE TRAINING ROOM IF ALTERNATE #2 IS ACCEPTED.

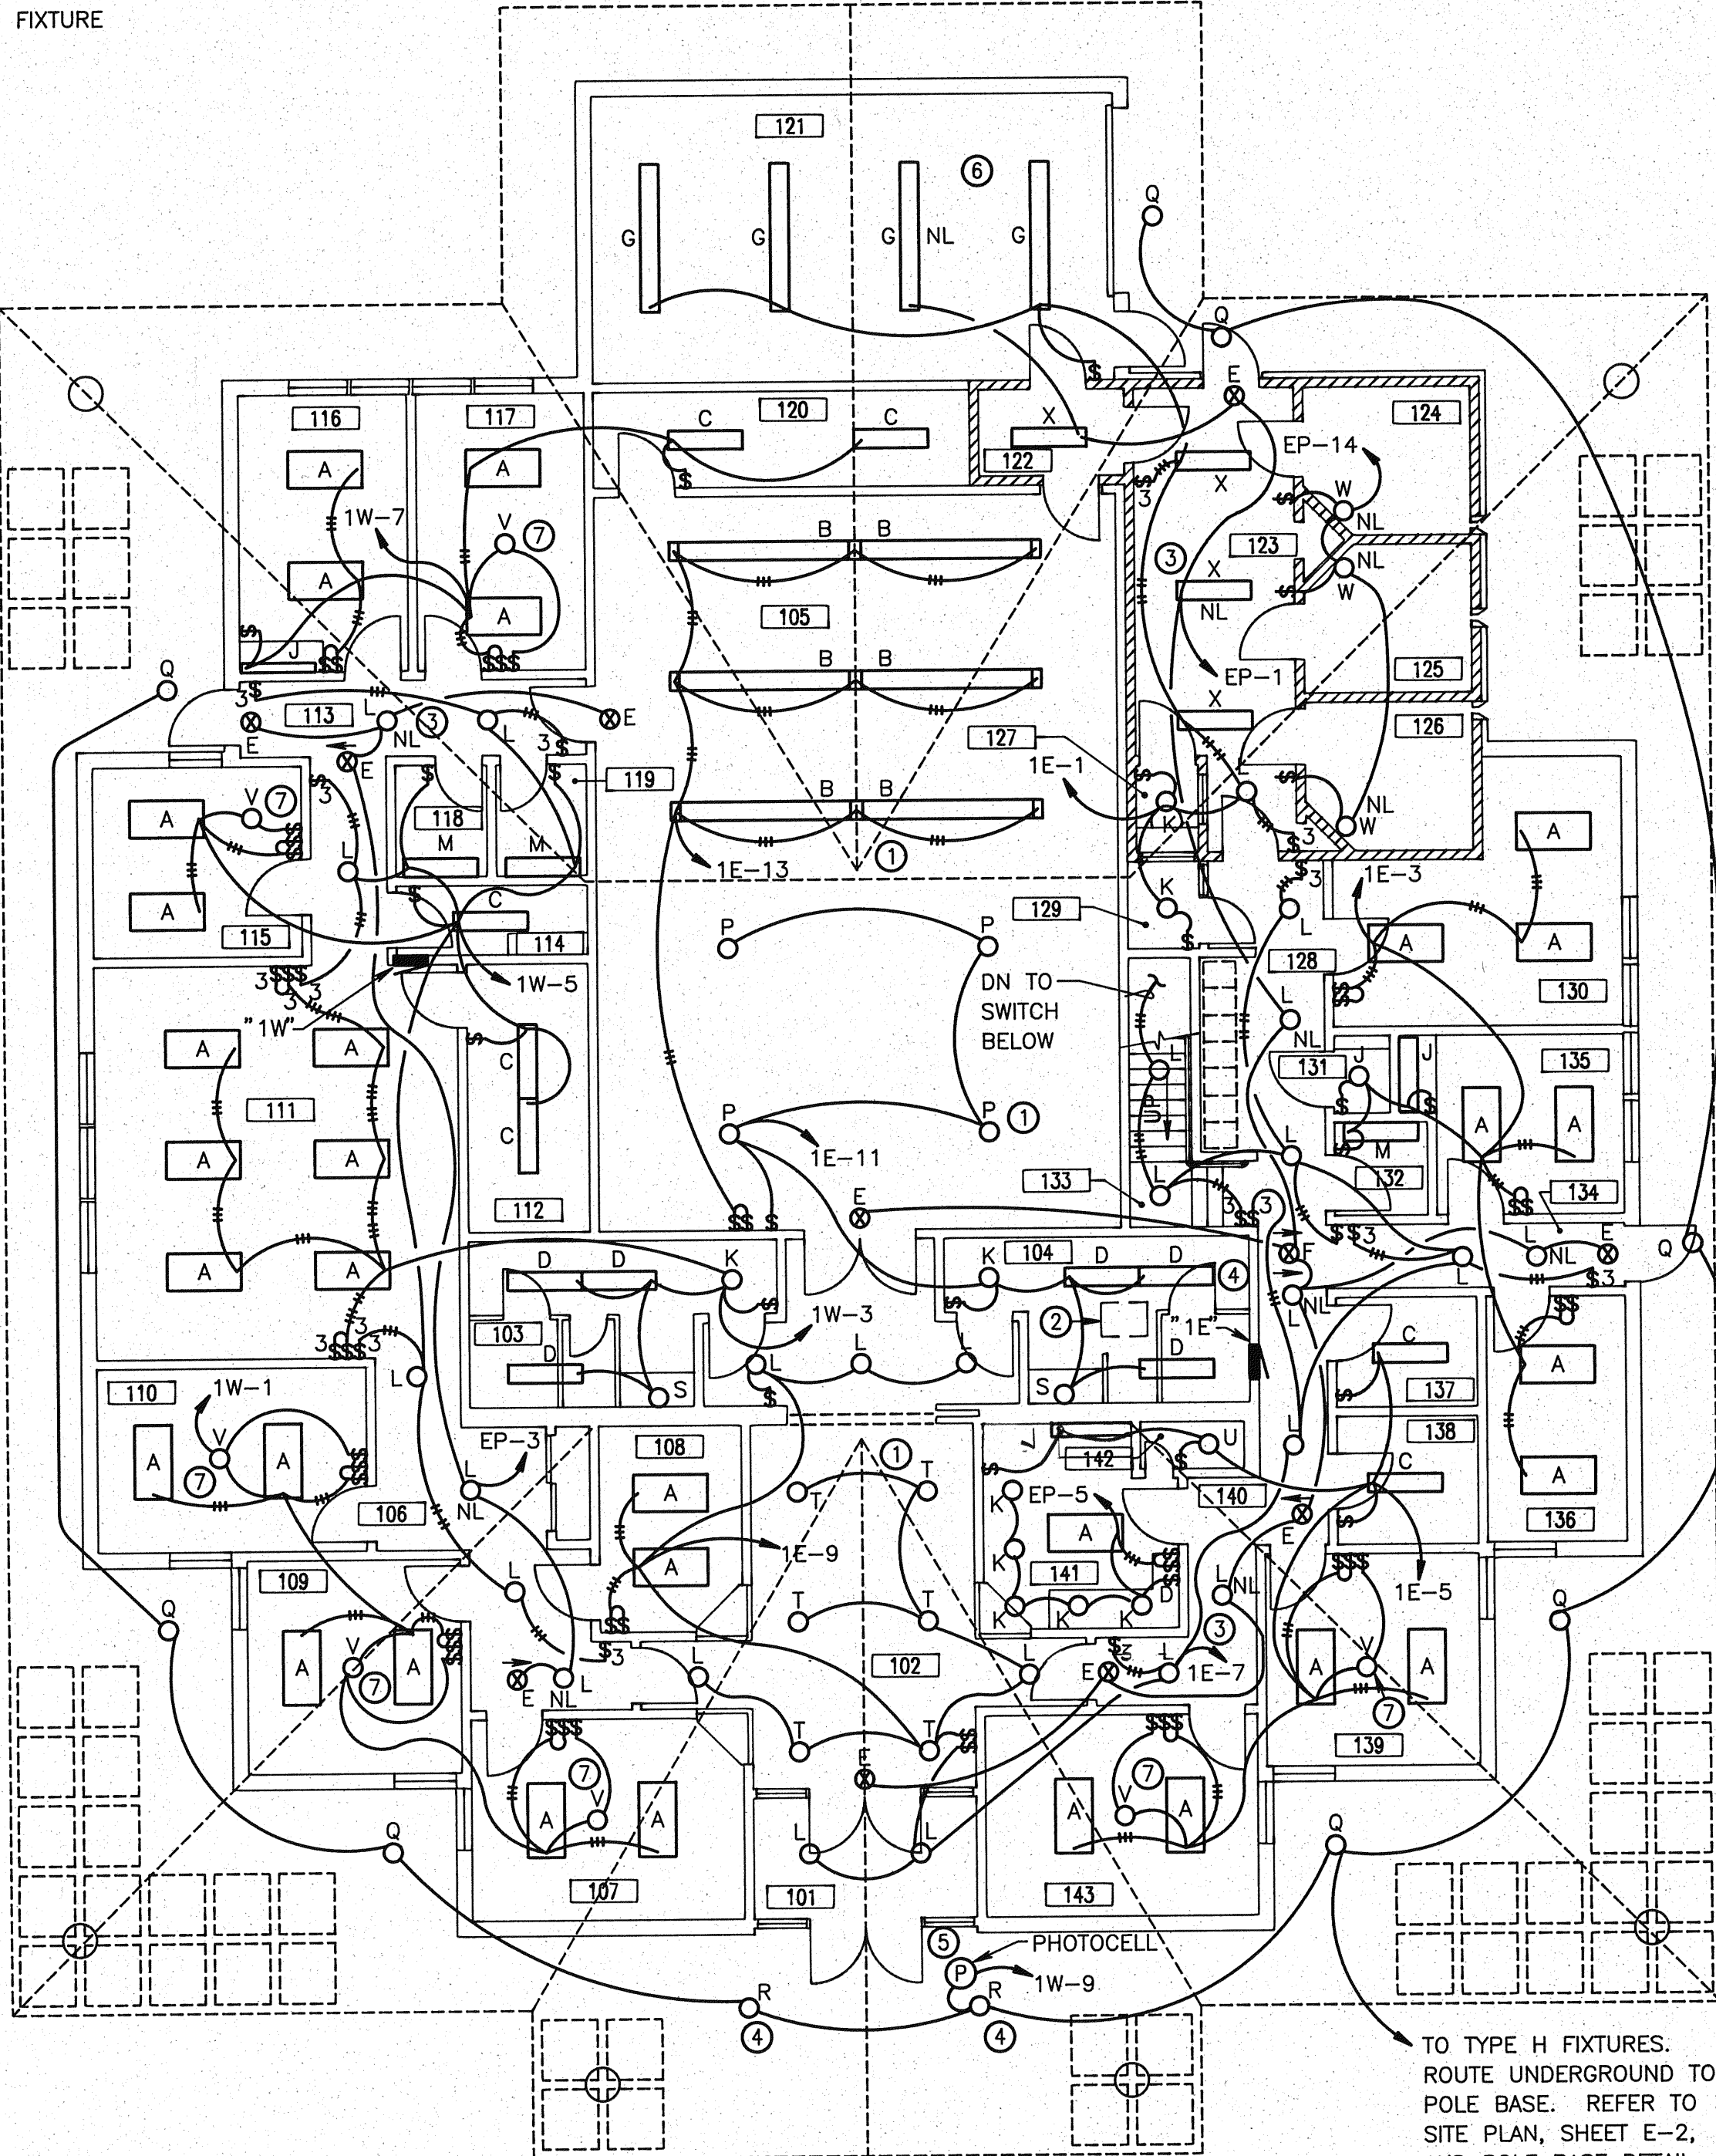


FIRST FLOOR PLAN - LIGHTING

SCALE: 1/8" = 1'-0"



CITY OF
COLLEGE PLACE
MUNICIPAL
BUILDING

COLLEGE PLACE,
WASHINGTON

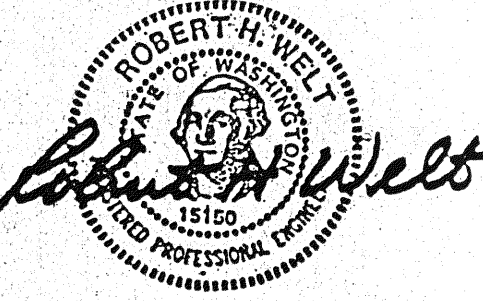

Architects & Engineers

INTEGRUS
ARCHITECTURE

244 West Main Avenue
Spokane, Washington 99201
509/838-8681
FAX 509/838-2194

Mechanical/Electrical Engineers

MW Consulting Engineers
Great Northwest Bldg., Suite 200
222 North Wall Street
Spokane, Washington 99201-0877
509/838-9020
FAX 509/838-1123

Job Number 9119.50
Drawn By DHP
Checked By RHW
Date 7-18-91
Revisions

Sheet Contents
MAIN & EXHIBENT
FLOOR PLANS -
LIGHTING

E3