


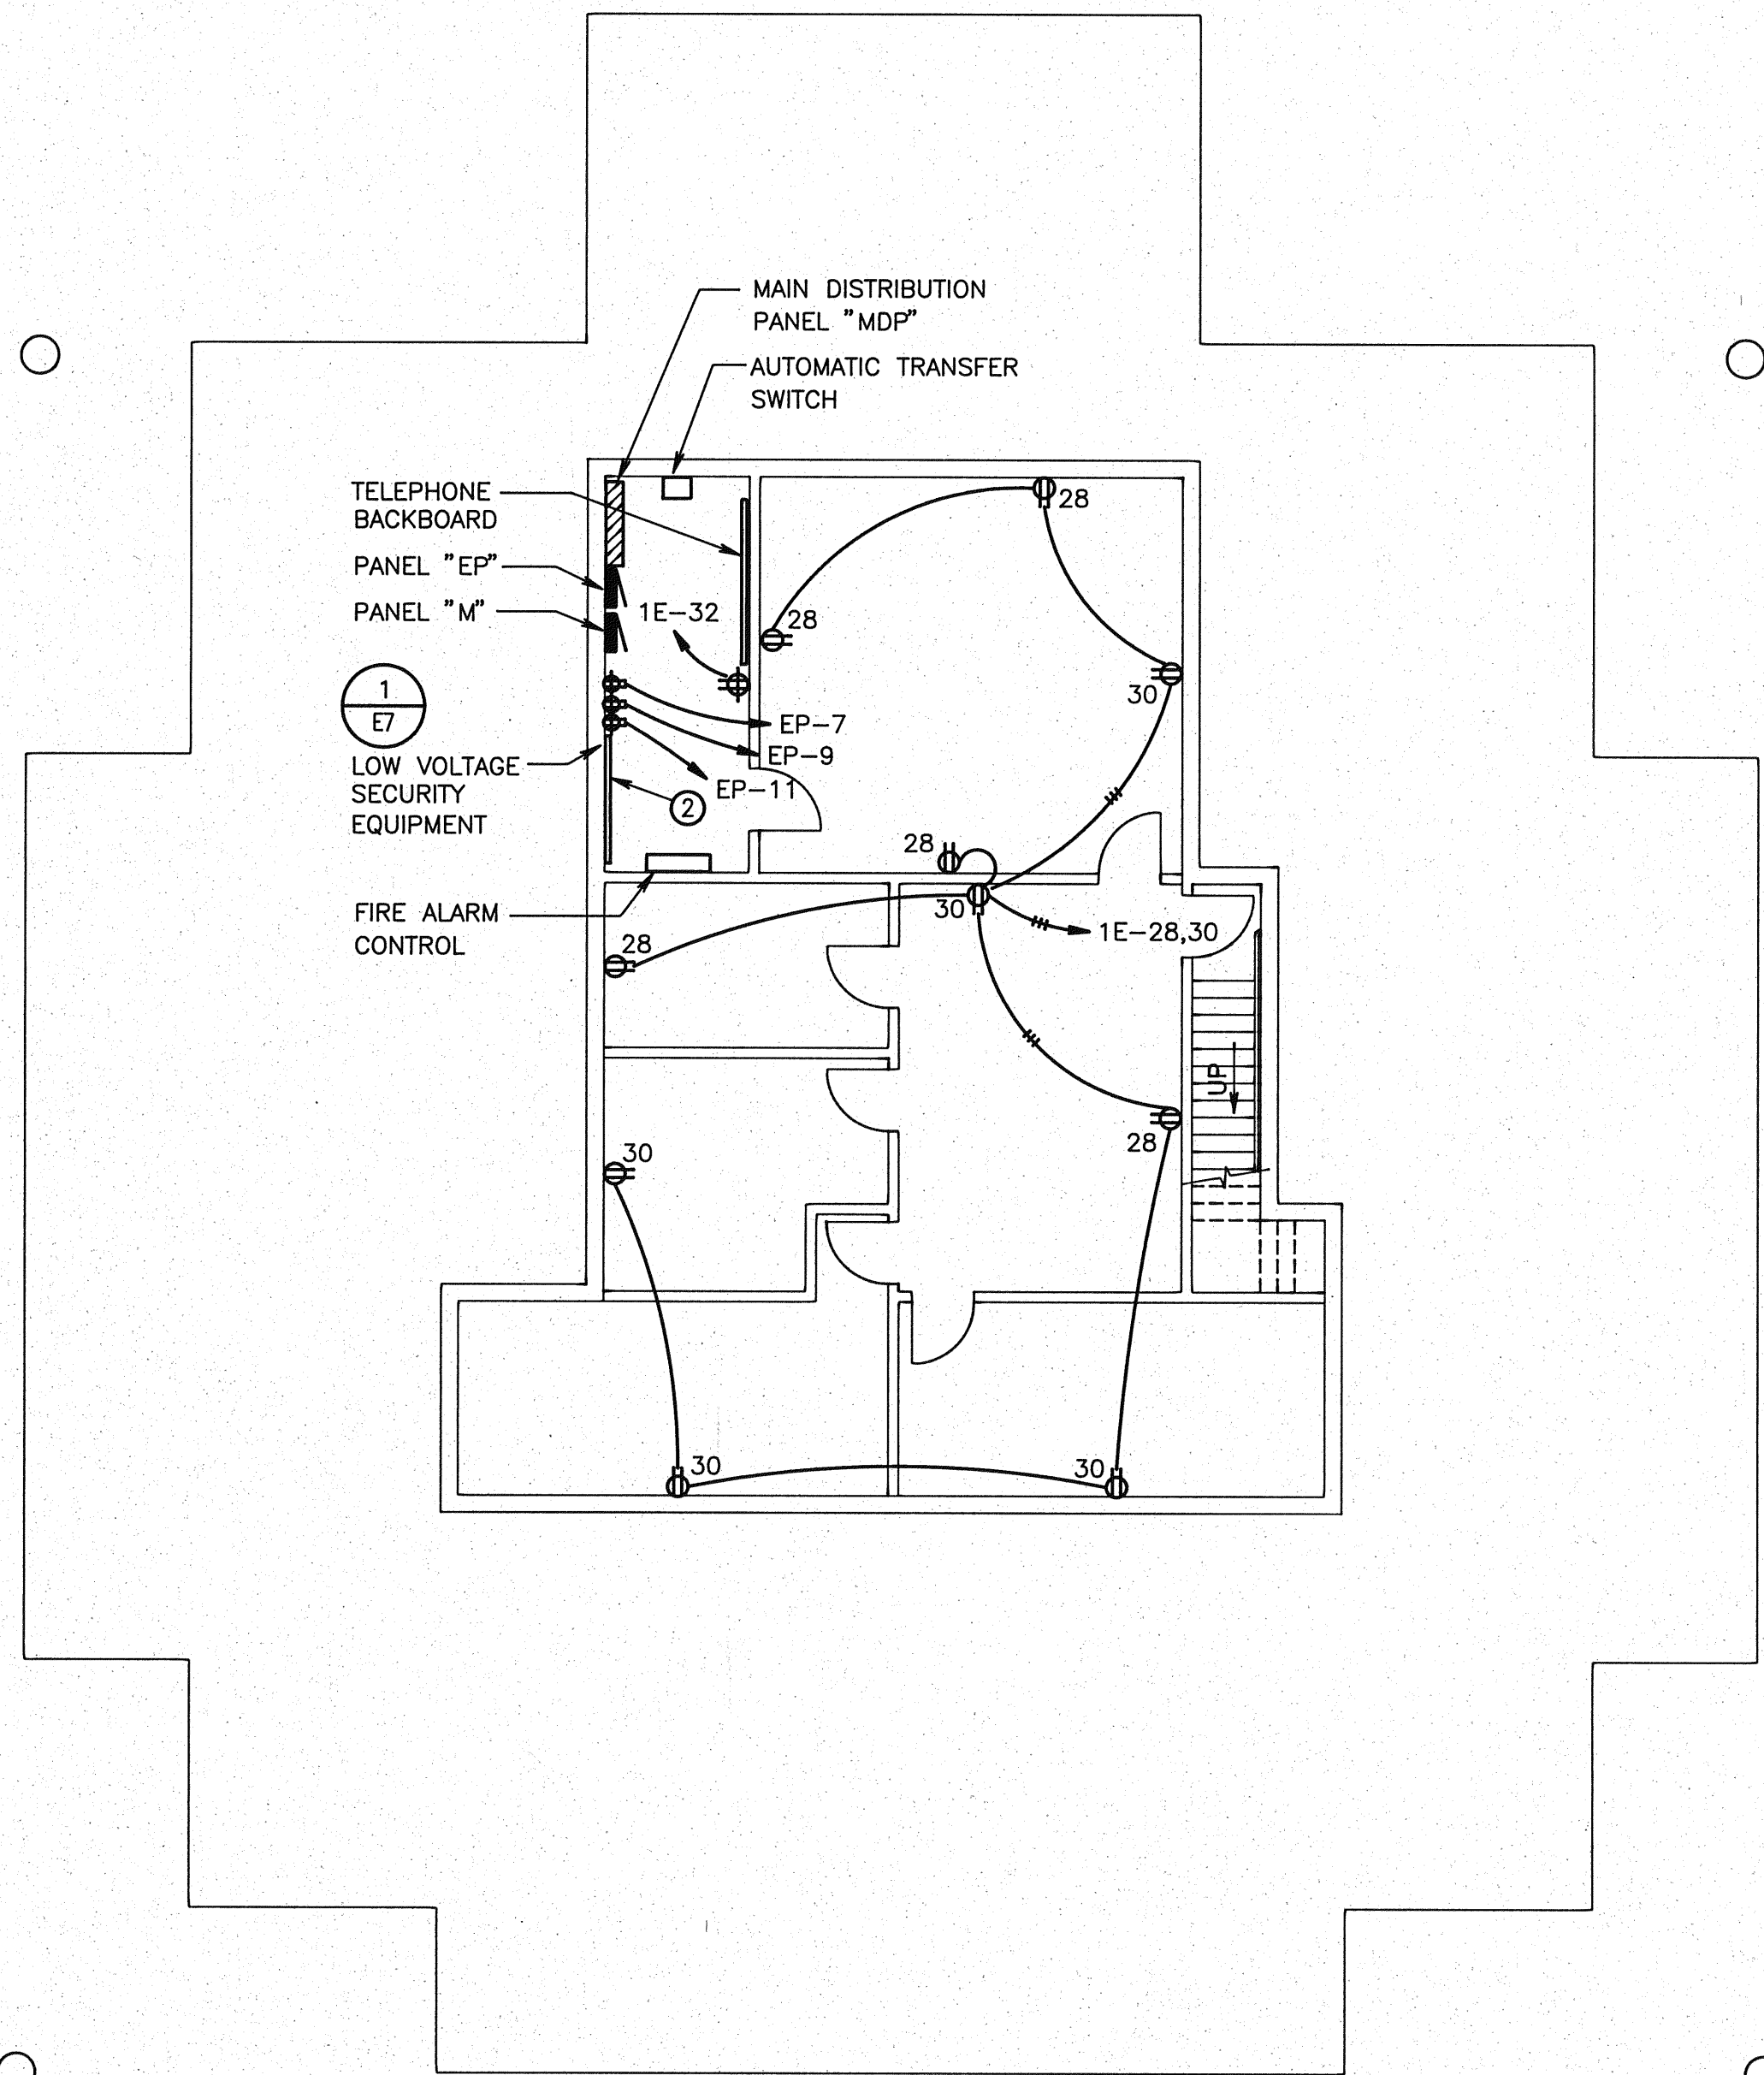


BASEMENT FLOOR PLAN - POWER

SCALE: 1/8" = 1'-0"



- NOTE:**
- FLOOR BOXES SHALL BE OF THE TYPE PROVIDING (2) TYPES OF POWER AND TWO TYPES OF DATA. PROVIDE (1) ISOLATED GROUND DUPLEX RECEPTACLE, (1) STANDARD DUPLEX RECEPTACLE, (1) TELEPHONE JACK WITH PIN CONFIGURATION AS DIRECTED, AND (1) COMPUTER JACK WITH PIN CONFIGURATION AS DIRECTED. FLOOR BOX SHALL BE HUBBELL #32FBSS WITH COVER, DUPLEX RECEPTACLE PLATE, AND TELEPHONE/DATA PLATE. ALL COLOR CHOICES SHALL BE MADE AT THE TIME SUBMITTAL COORDINATE WITH CARPET INSTALLER AS REQUIRED. PROVIDE ALL MOUNTING HARDWARE AS REQUIRED.
 - LOW VOLTAGE SECURITY EQUIPMENT TO BE MOUNTED ON THIS WALL. SEE DETAIL #1, SHEET E7 FOR FURTHER INFORMATION SPECIFIC TO PROPOSED EQUIPMENT POSITIONING ON WALL.

- PROVIDE ELECTRIC BASEBOARD HEATER THIS LOCATION. CADET #4F-1000-120V, OR APPROVED EQUAL.
- PROVIDE JUNCTION BOX FOR HAND DRYER. 1.2KVA, 120 VOLT, SINGLE PHASE. MAKE ALL REQUIRED CONNECTIONS.
- PROVIDE JUNCTION BOX FOR SECURITY ELECTRONICS EQUIPMENT LOCATED IN THIS ROOM. SEE ARCHITECTURAL 1/4" SCALE PLAN, AND COORDINATE EXACT PLACEMENT OF EQUIPMENT WITH OWNER. ALL WORK IN REGARDS TO SECURITY ELECTRONICS INSTALLATION TO BE CLOSELY COODINATED WITH OWNER.

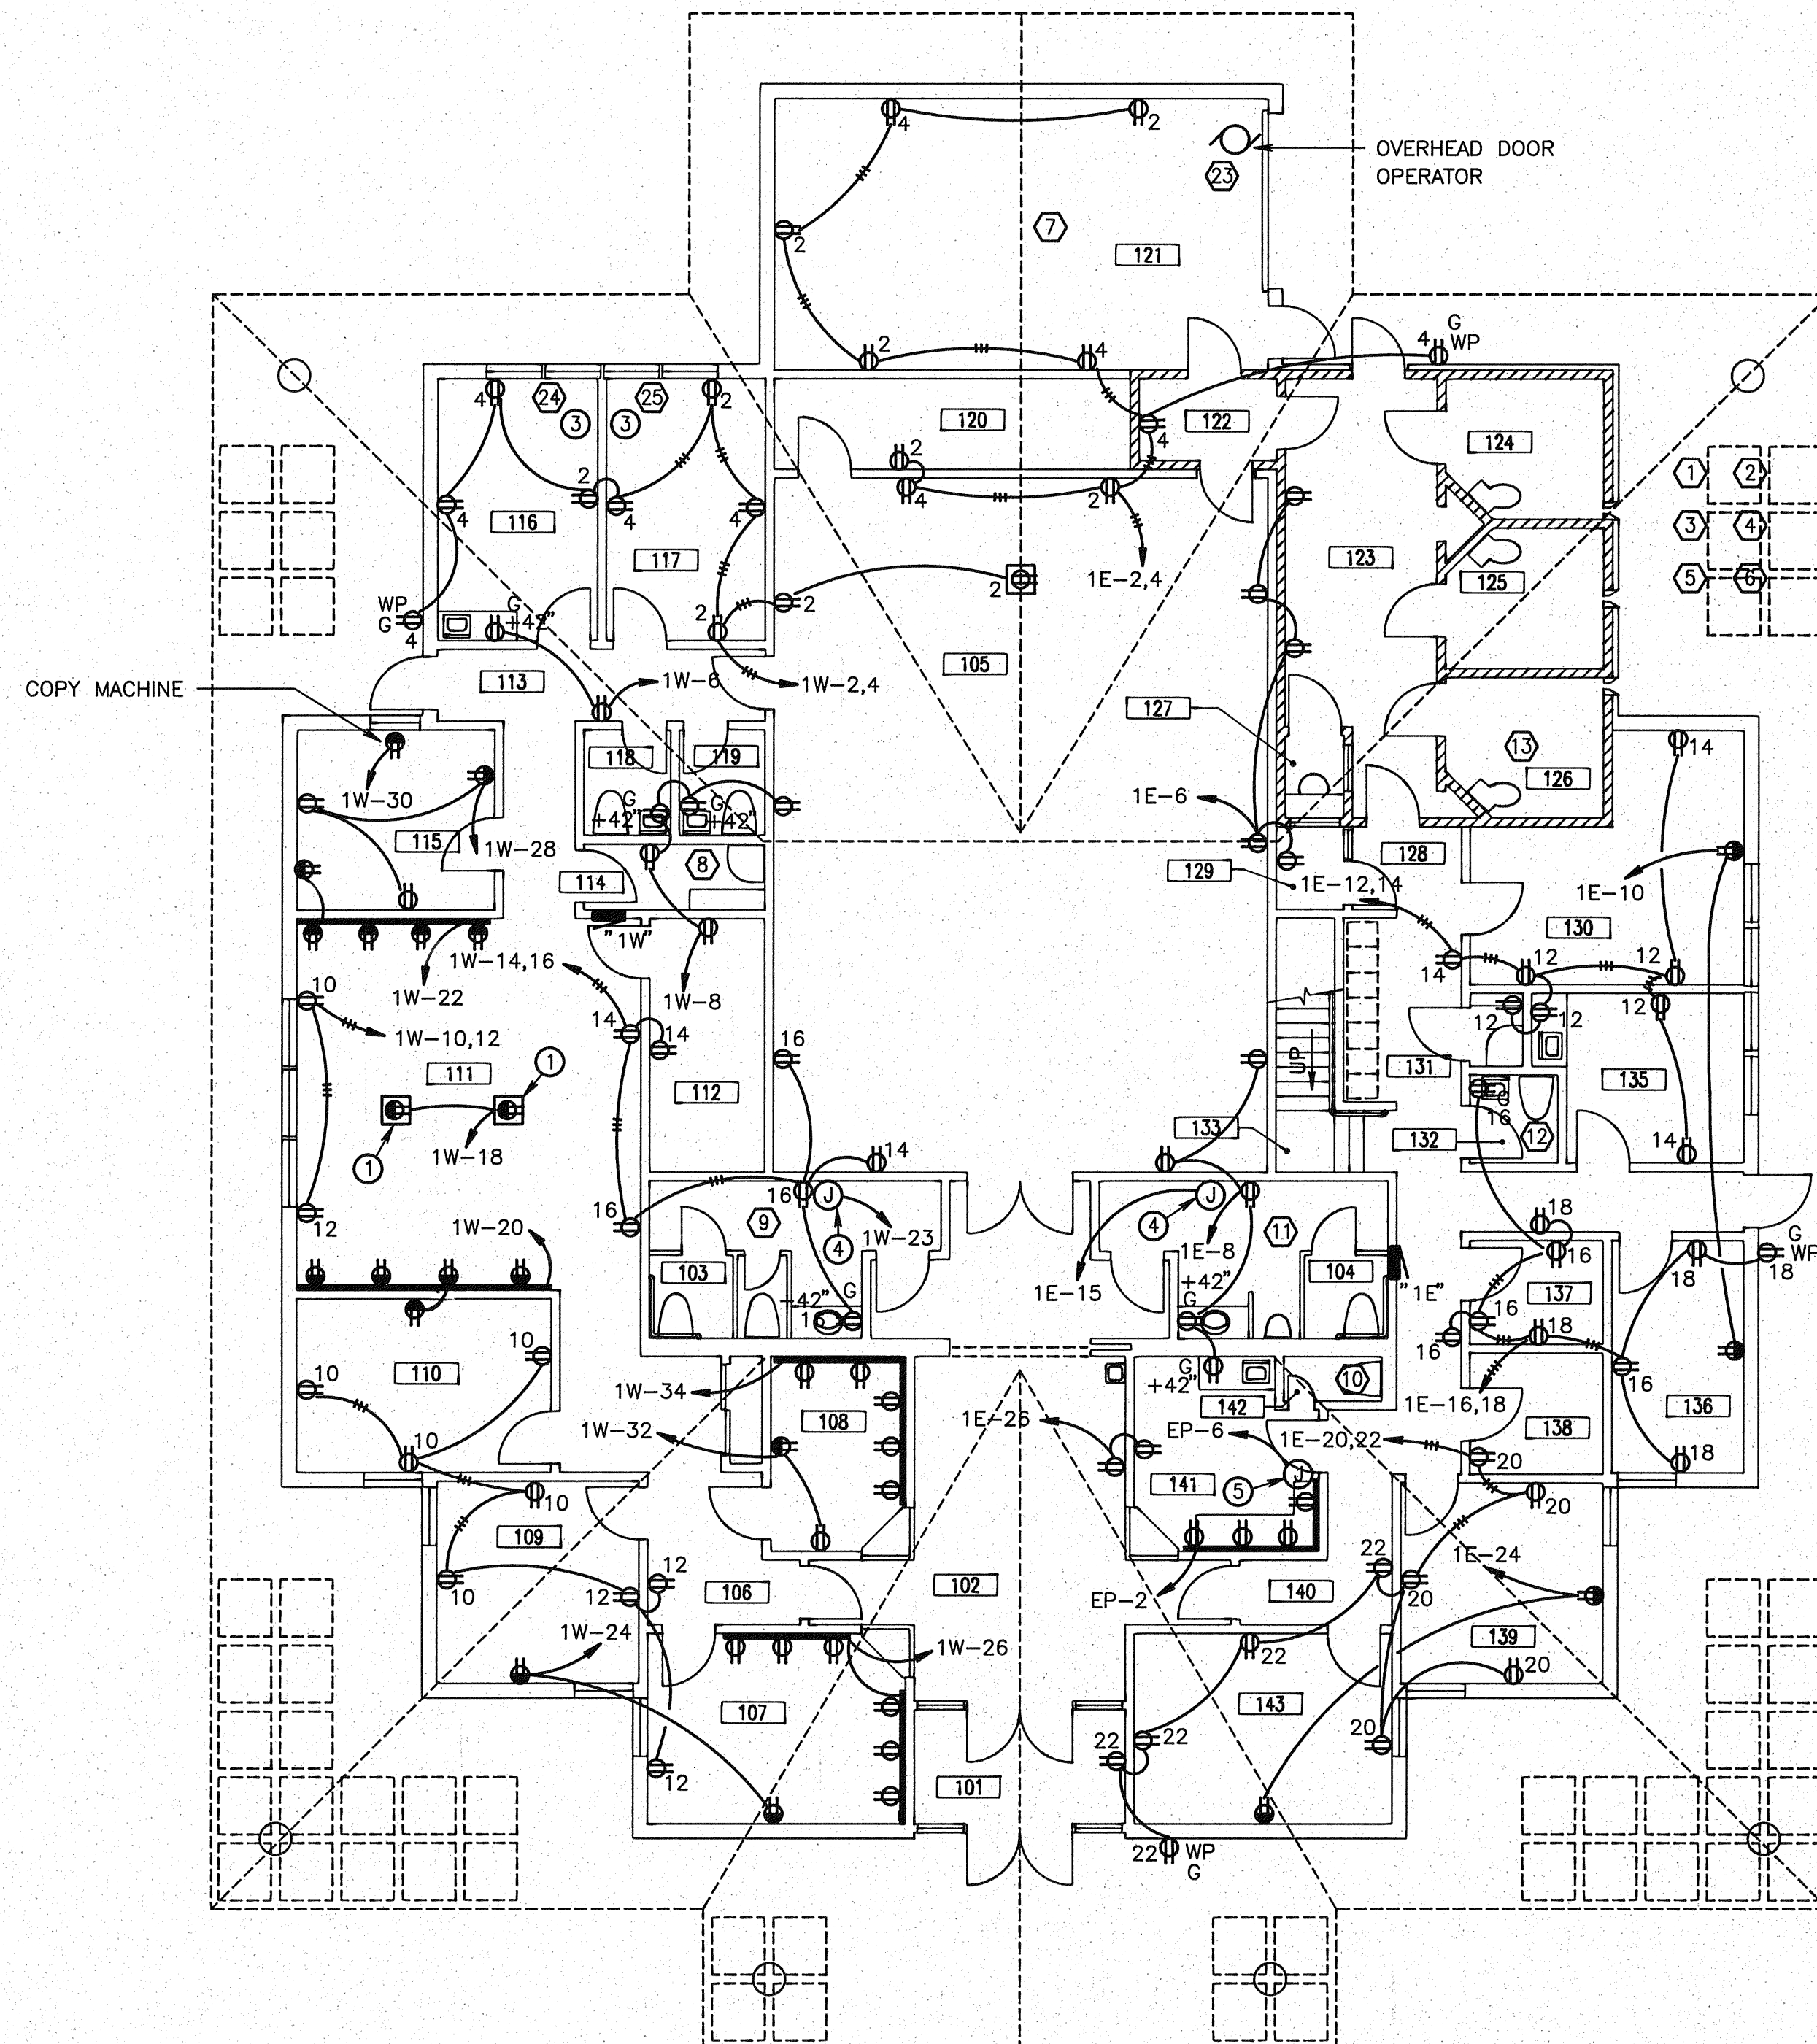

FIRST FLOOR PLAN - POWER

SCALE: 1/8" = 1'-0"



**CITY OF
COLLEGE PLACE
MUNICIPAL
BUILDING**

COLLEGE PLACE,
WASHINGTON



Architects & Engineers

**INTÉGRUS
ARCHITECTURE**

244 West Main Avenue
Spokane, Washington 99201
509/838-8681
FAX 509/838-2194

Mechanical/Electrical Engineers

MW Consulting Engineers
Great Northwest Bldg., Suite 200
222 North Wall Street
Spokane, Washington 99201-0877
509/838-9020
FAX 509/838-1123

Job Number 9119.50
Drawn By *RHW*
Checked By *RHW*
Date 9-18-91
Revisions

Sheet Contents
MAIN & BASEMENT
FLOOR PLANS -
POWER

E4