


CITY OF COLLEGE PLACE MUNICIPAL BUILDING

COLLEGE PLACE,
WASHINGTON

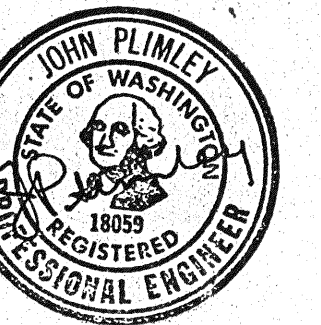

Architects & Engineers

INTEGRUS ARCHITECTURE

244 West Main Avenue
Spokane, Washington 99201
509/838-8681
FAX 509/838-2194

Mechanical/Electrical Engineers

MW Consulting Engineers
Great Northwest Bldg., Suite 200
222 North Wall Street
Spokane, Washington 99201-0877
509/838-9020
FAX 509/838-1123

Job Number 9119.50

Drawn By E.P.





Checked By J.C.

Date 9/10/91

Revisions


Sheet Contents MECH. FLR,
ROOF FRAMING,
FTG. & FLR. FRAMING,
BASEMENT FOUNDATION

S2.1

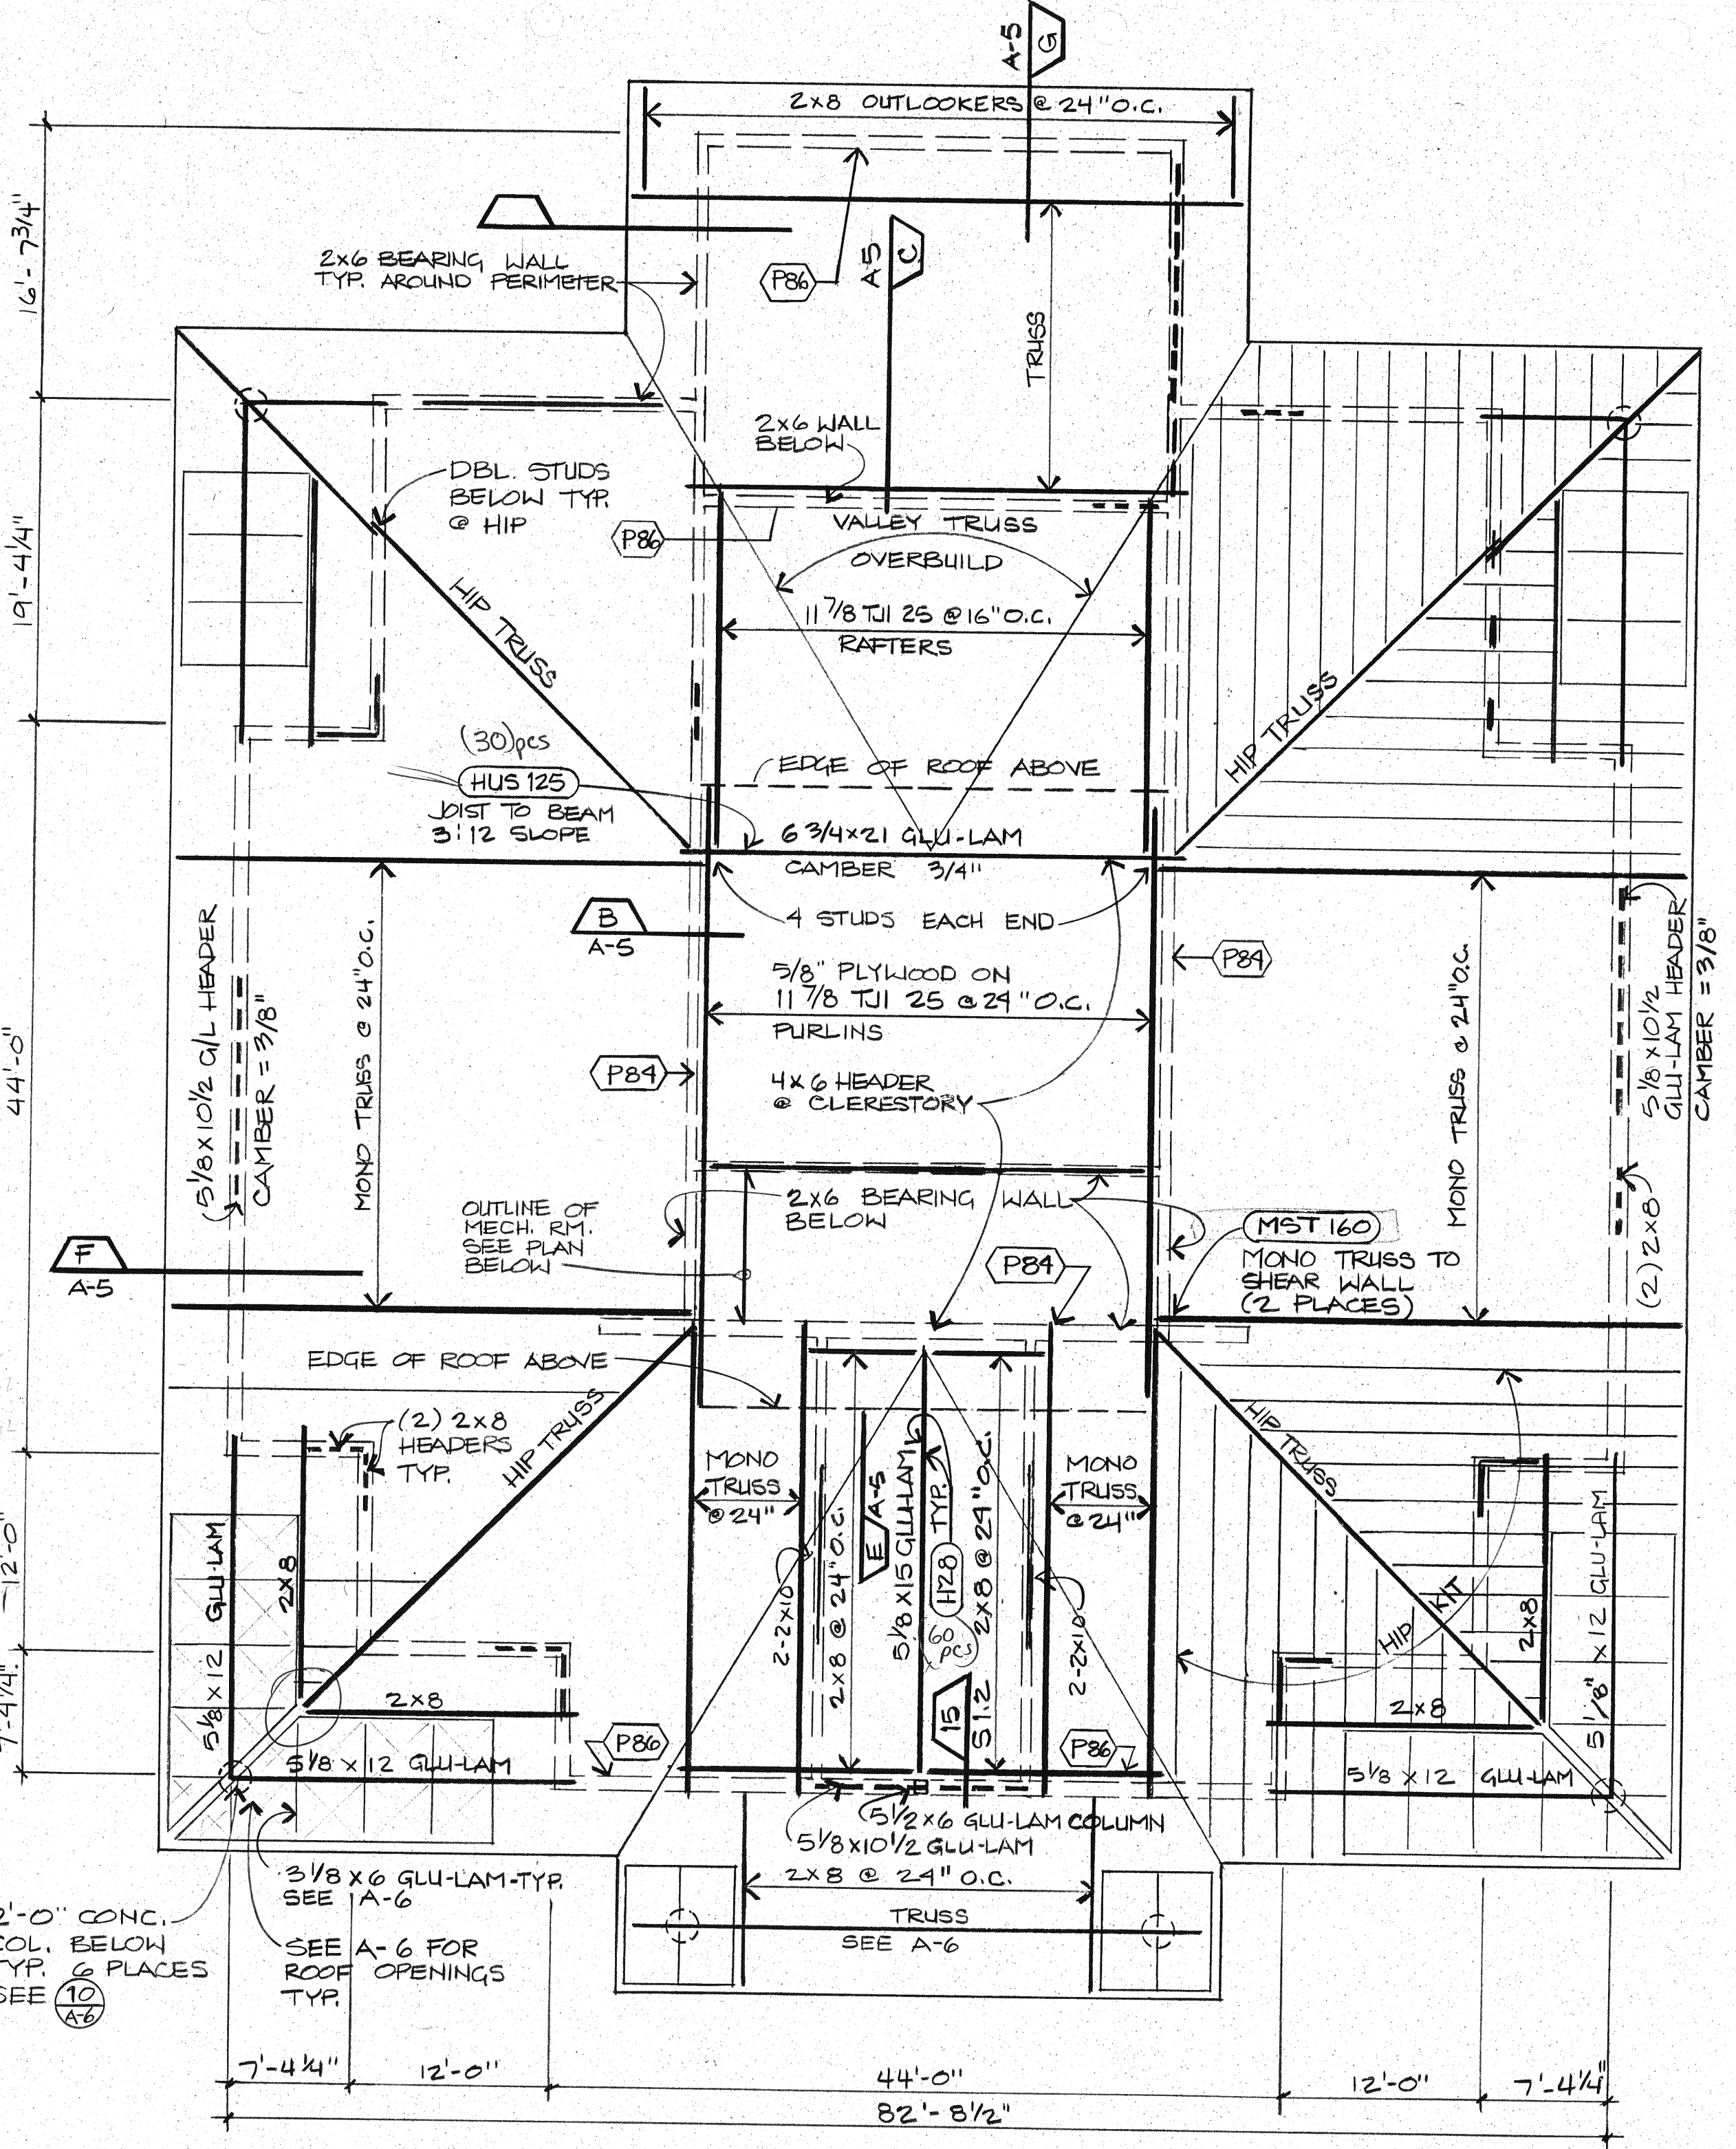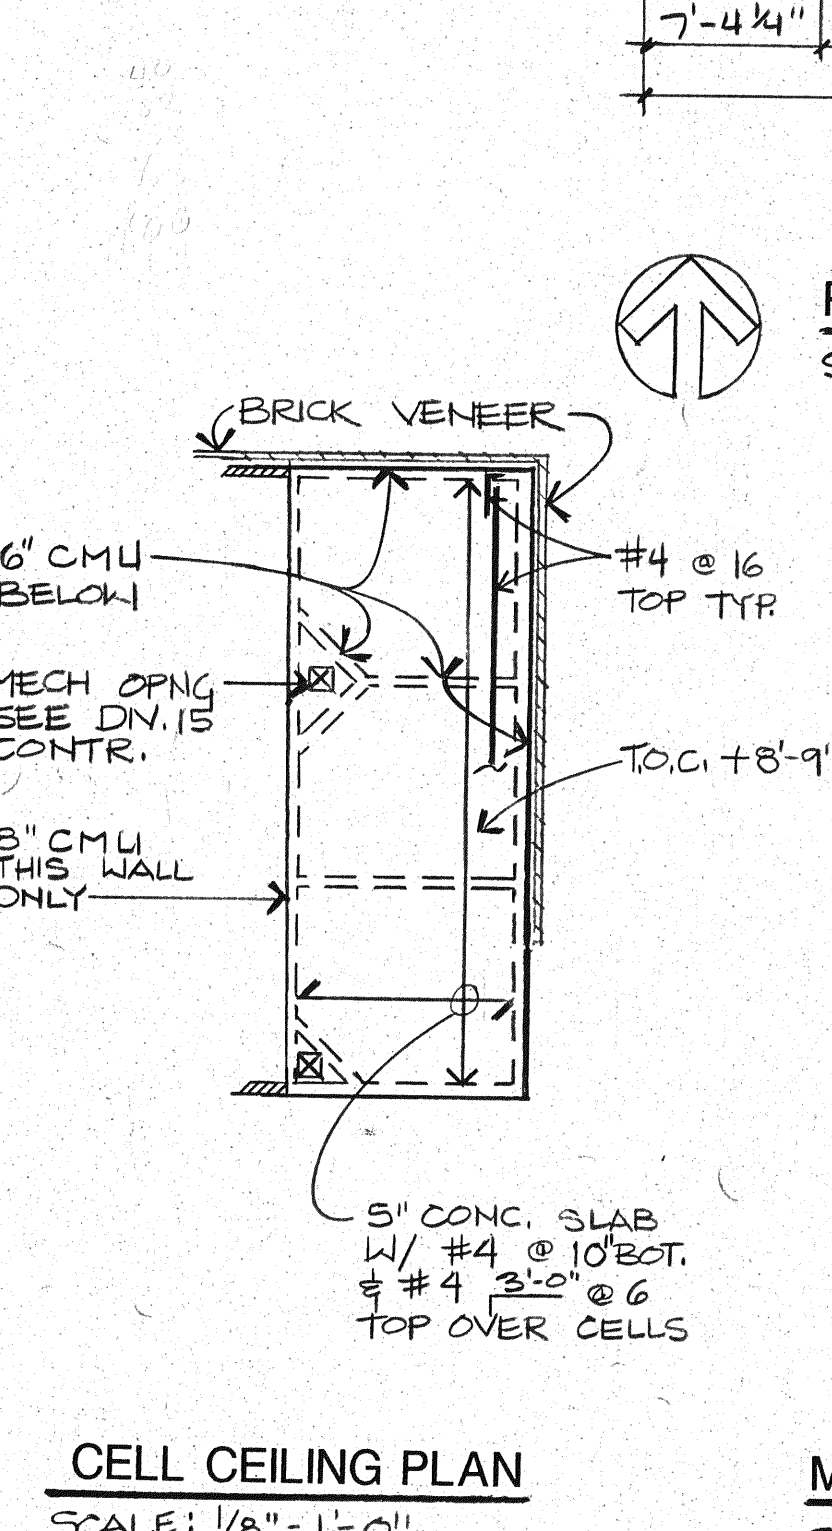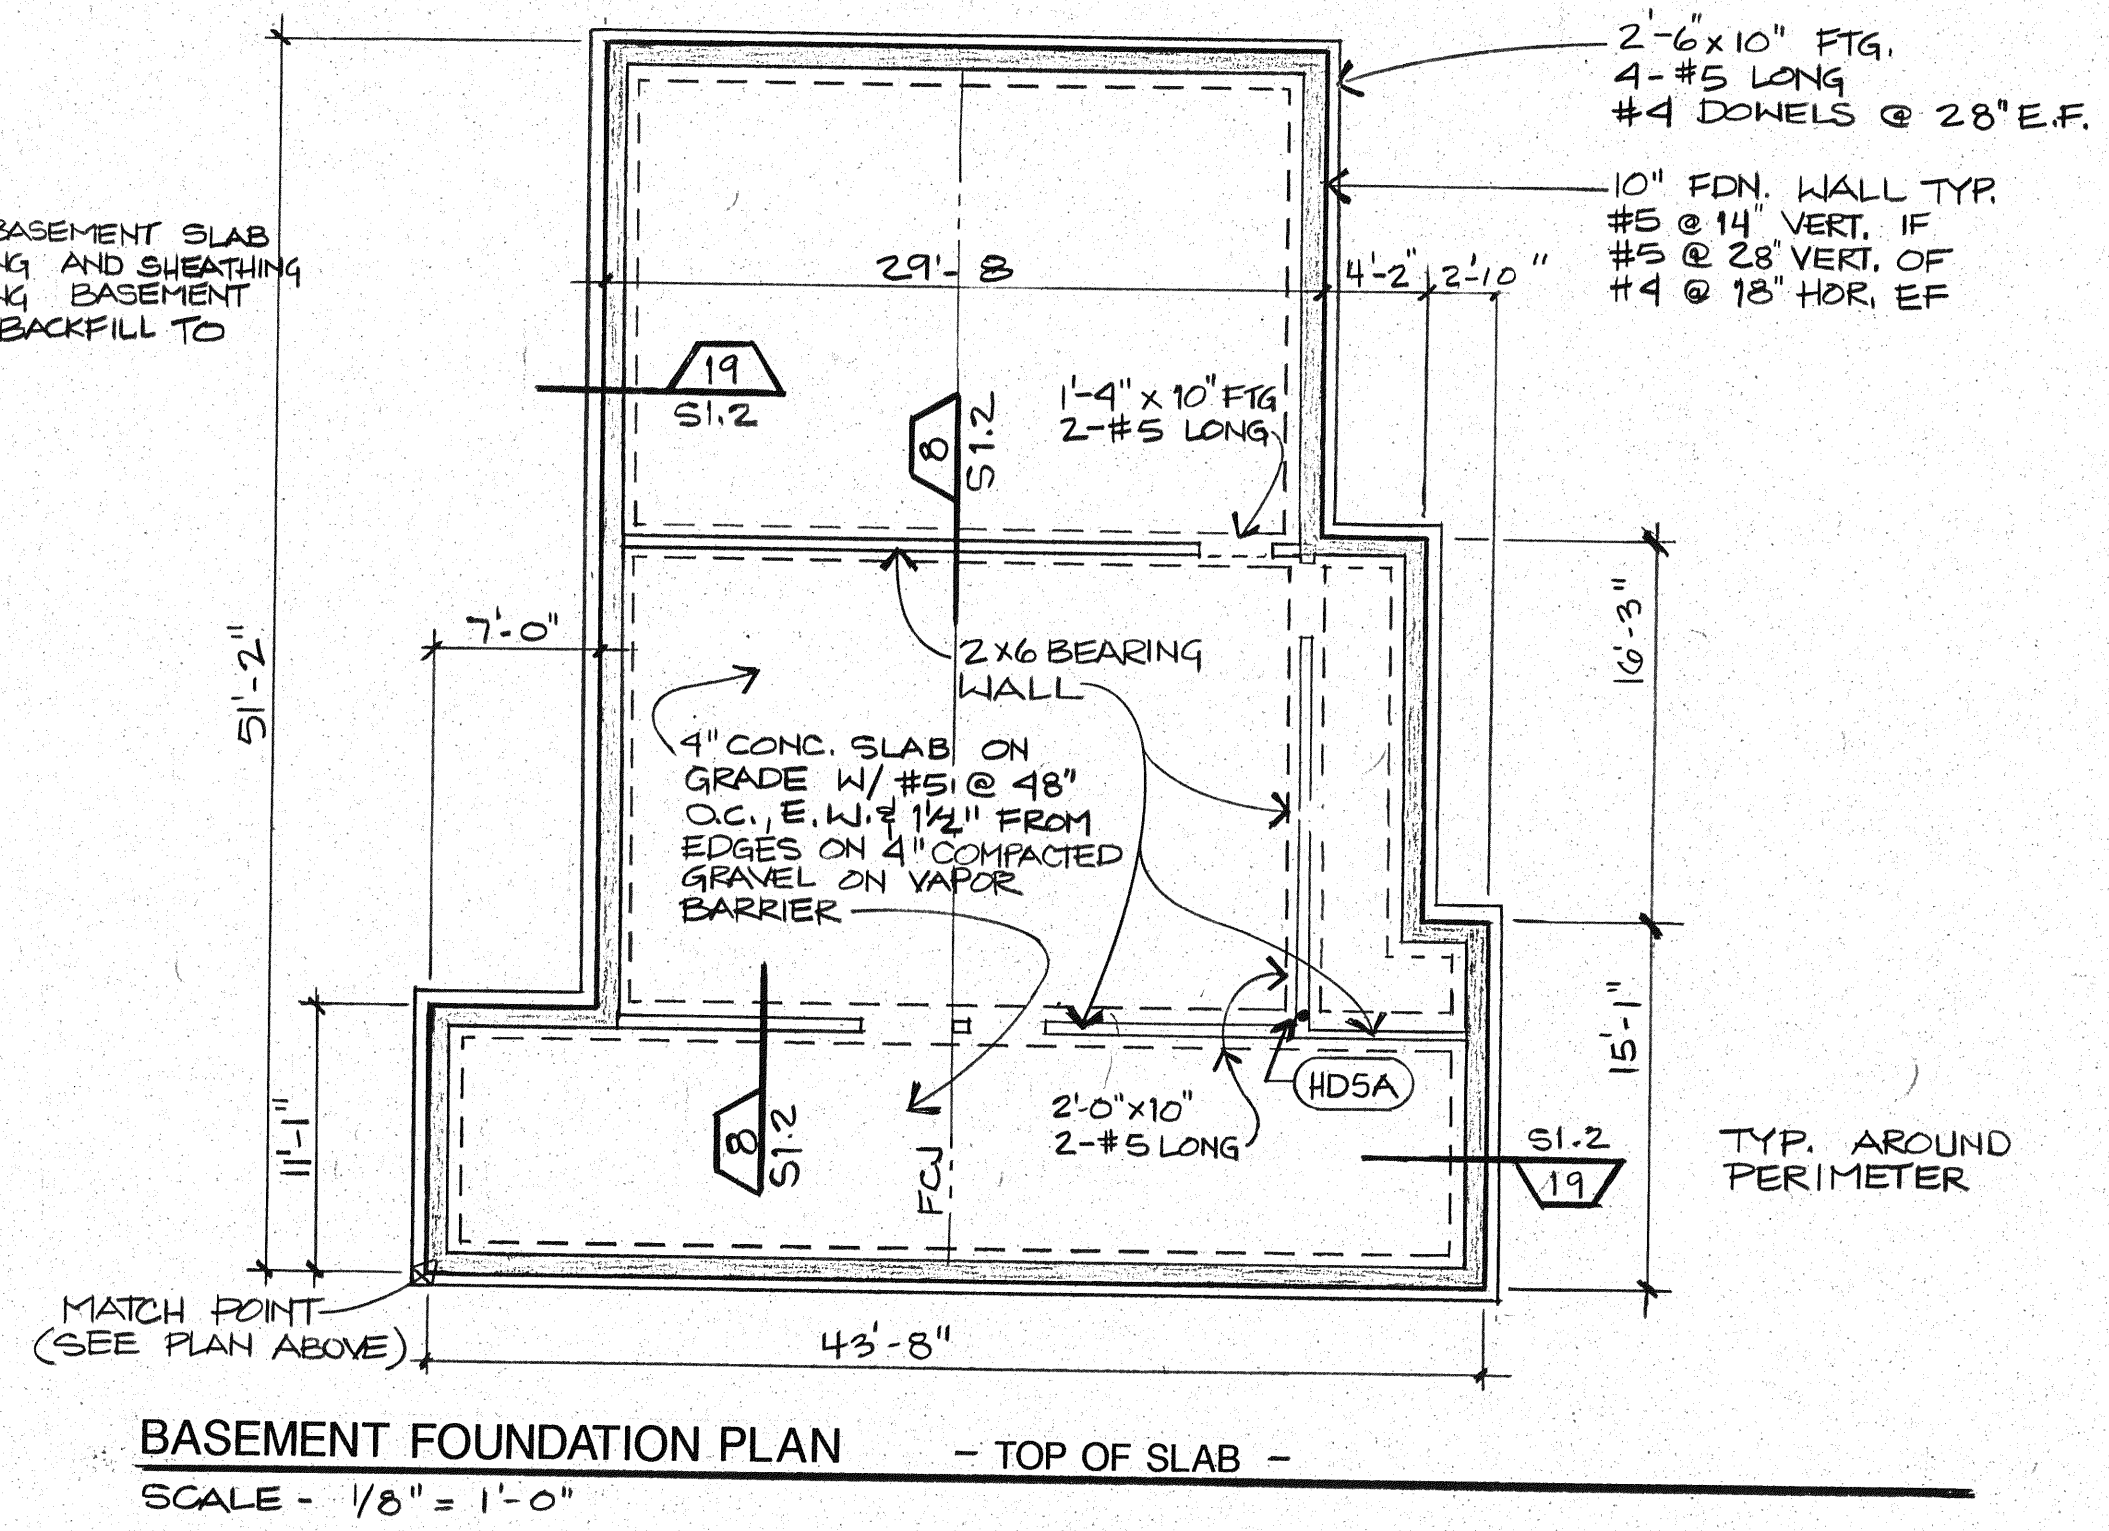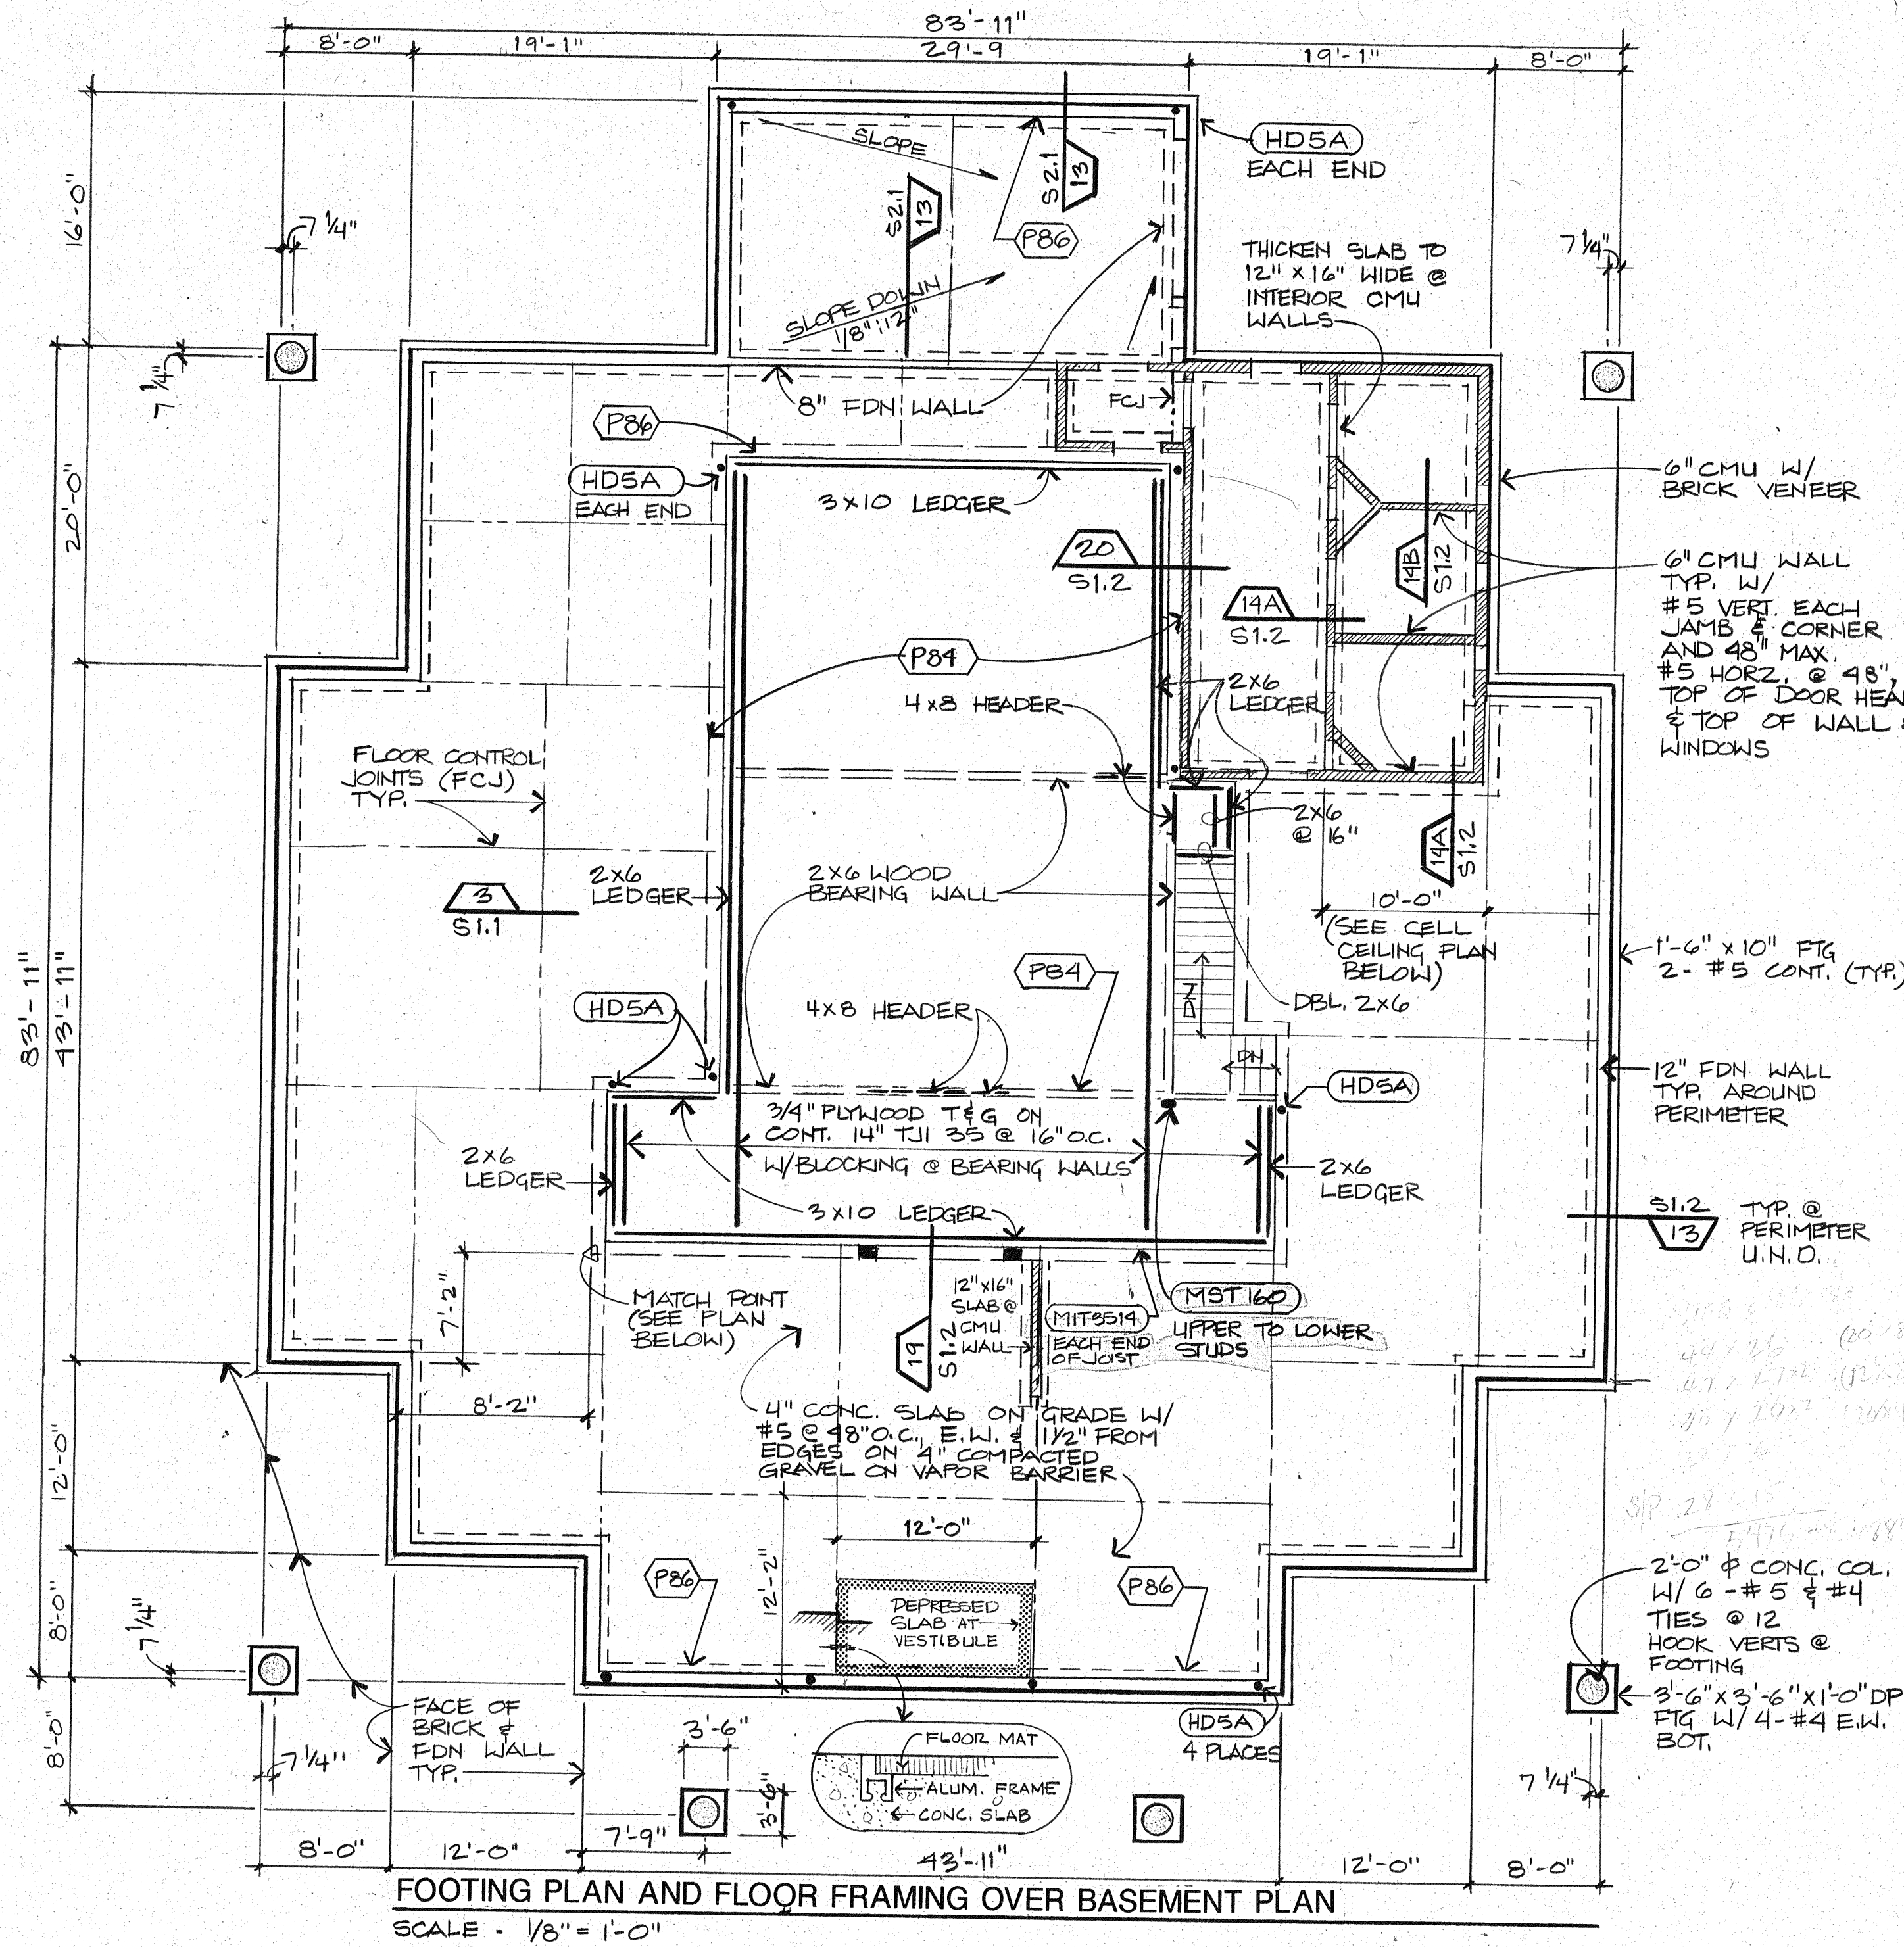

MECHANICAL FLOOR PLAN

SCALE - 1/8" = 1'-0"

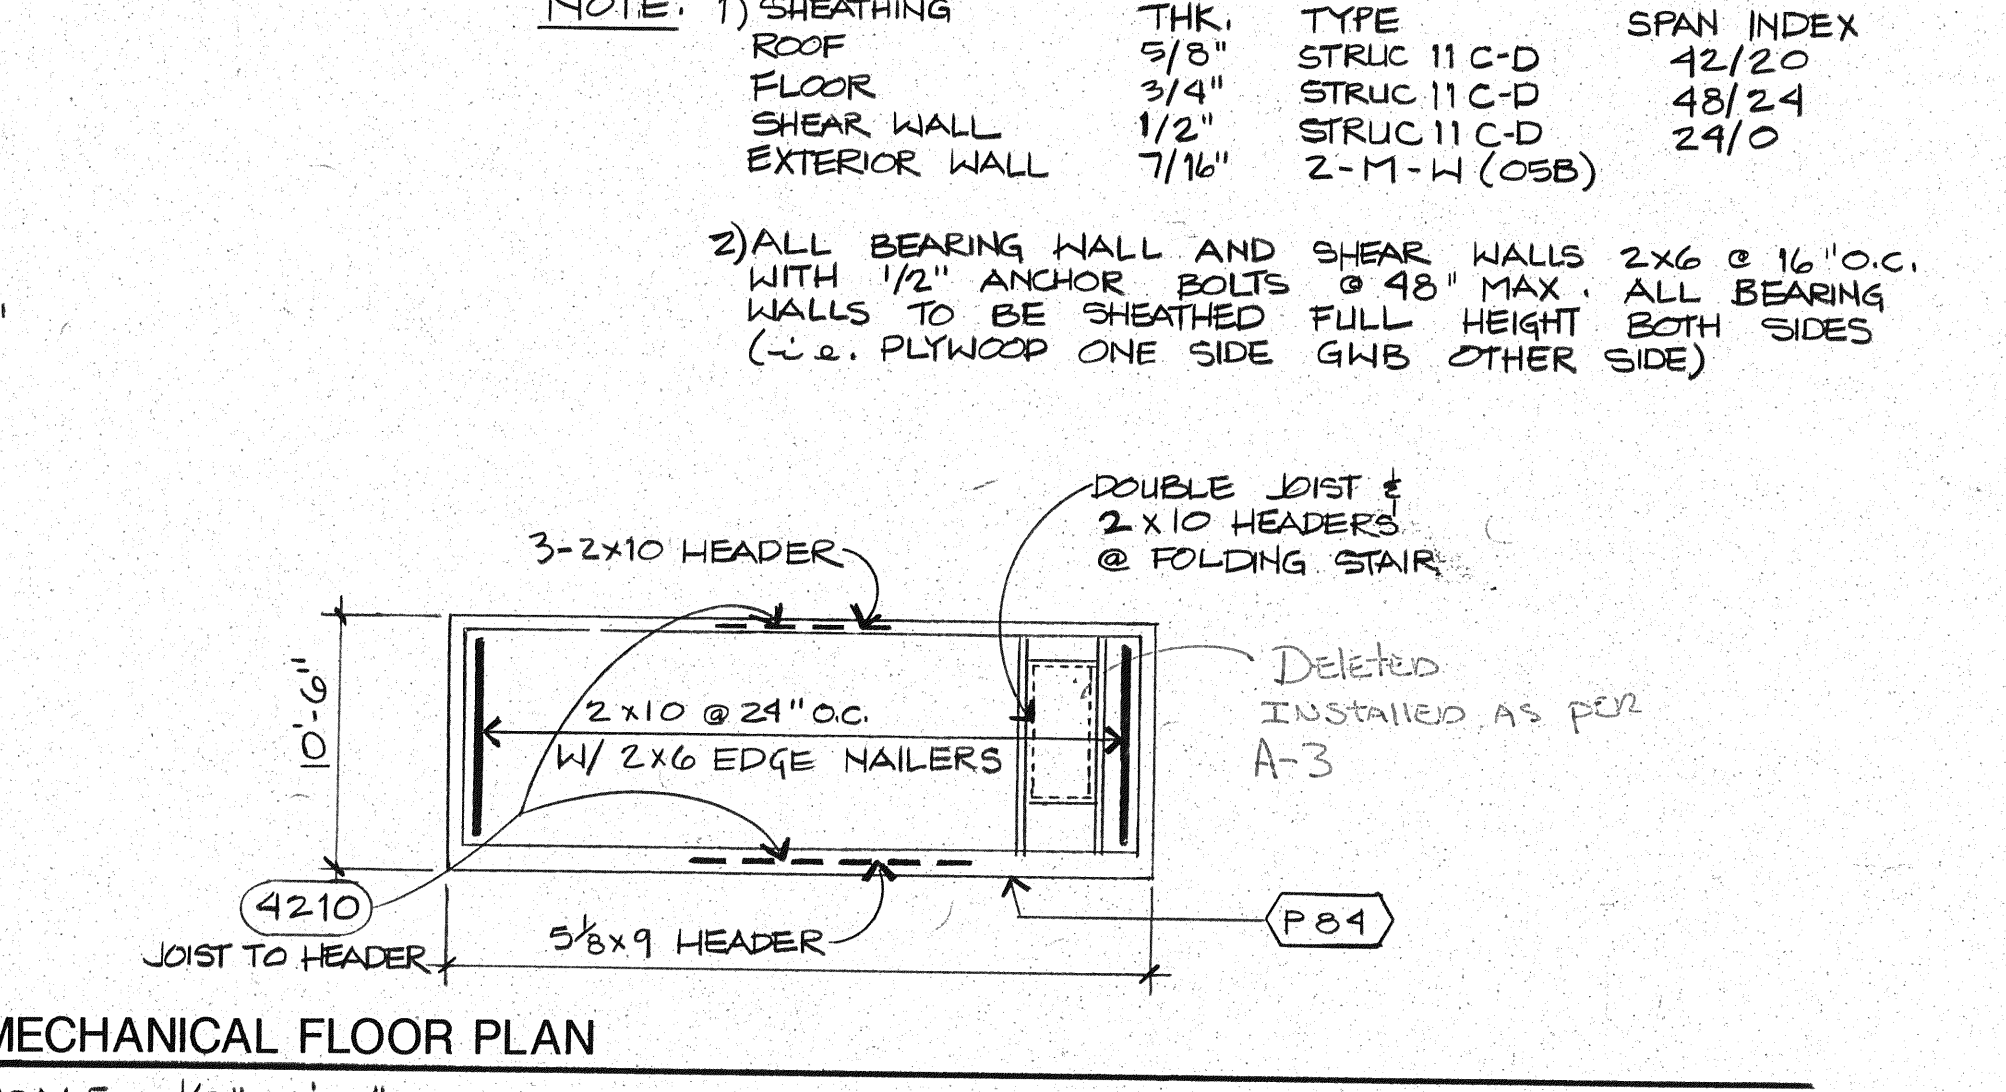

NOTE: 1) SHEATHING

THK.	TYPE	SPAN INDEX
5/8"	STRUC 11 C-D	42/20
3/4"	STRUC 11 C-D	48/24
1/2"	STRUC 11 C-D	24/0
7/16"	2-M-W (OSB)	

2) ALL BEARING WALL AND SHEAR WALLS 2'x6 @ 16" O.C. WITH 1/2" ANCHOR BOLTS @ 48" MAX. ALL BEARING WALLS TO BE SHEATHED FULL HEIGHT BOTH SIDES (i.e. PLYWOOD ONE SIDE GWB OTHER SIDE)

NOTE: INSTALL BASEMENT SLAB AND FLOOR FRAMING AND SHEATHING BEFORE BACKFILLING BASEMENT WALLS. COMPACT BACKFILL TO 95% DENSITY

DOUBLE JOIST & 2'x10 HEADERS @ FOLDING STAIR
Deleted
Installed as per A-3